


DEFIANCE COUNTY LANDFILL EXPANSION

PHASES 8 & 9

BAT CELL & SUPPORT STRUCTURES CONSTRUCTION

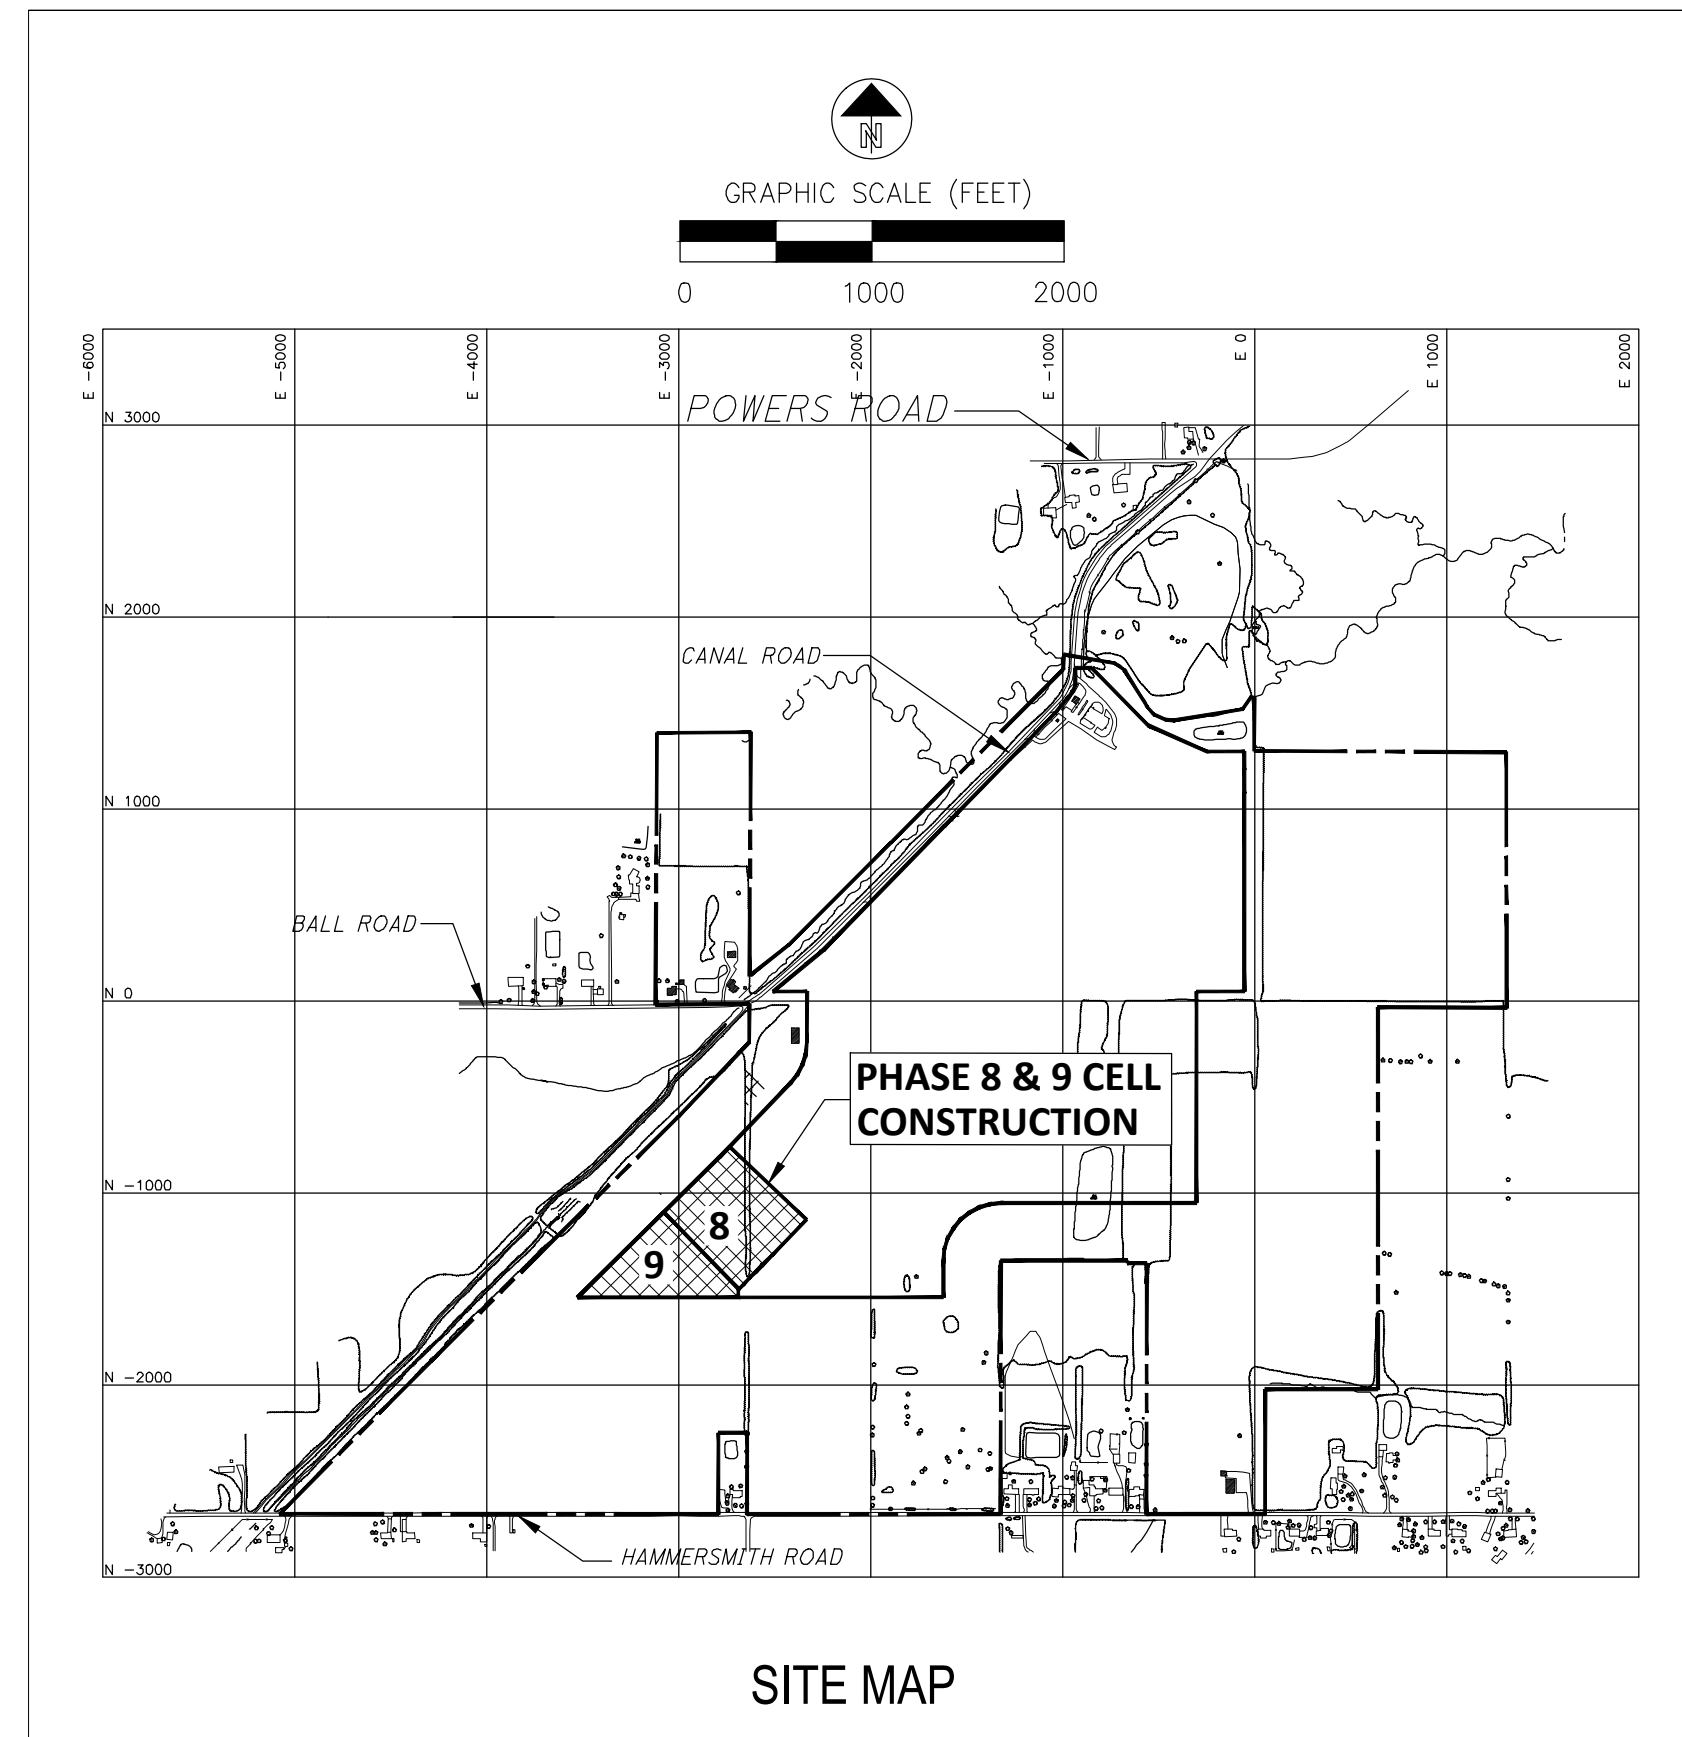

OWNER/OPERATOR
DEFIANCE COUNTY
BOARD OF COMMISSIONERS
500 COURT STREET
DEFIANCE, OHIO 43512
(419) 782-4761


FACILITY ADDRESS
DEFIANCE COUNTY LANDFILL
13207 CANAL ROAD
DEFIANCE, OHIO 43512
(419) 784-2844



LEGAL DESCRIPTION

PROPERTY LOCATION - EXISTING LANDFILL
SECTIONS 4 AND 5, TOWN 3 NORTH, RANGE 4 EAST,
DEFIANCE TOWNSHIP, DEFIANCE COUNTY, OHIO
LYING EAST OF CANAL ROAD & SOUTH OF THREE MILE CREEK

INDEX OF SHEETS

TITLE SHEET	1
GENERAL FACILITY ARRANGEMENT	2
EXISTING CONDITIONS	3
EXCAVATION & GRADING PLAN	4
RECOMPACTED SOIL LINER & GEOMEMBRANE SUBGRADE PLAN	5
LEACHATE DRAINAGE LAYER PLAN	6
DETAILS - LINER SYSTEM	7
DETAILS - CELL CONSTRUCTION	8
LEACHATE COLLECTION AND REMOVAL PLAN	9
DETAILS - LEACHATE COLLECTION AND REMOVAL SYSTEMS 1	10
DETAILS - LEACHATE COLLECTION AND REMOVAL SYSTEMS 2	11
DETAILS - LEACHATE COLLECTION AND REMOVAL SYSTEMS 3	12
CONSTRUCTION POINTS	13
ELECTRICAL - OVERALL POWER PLAN	14

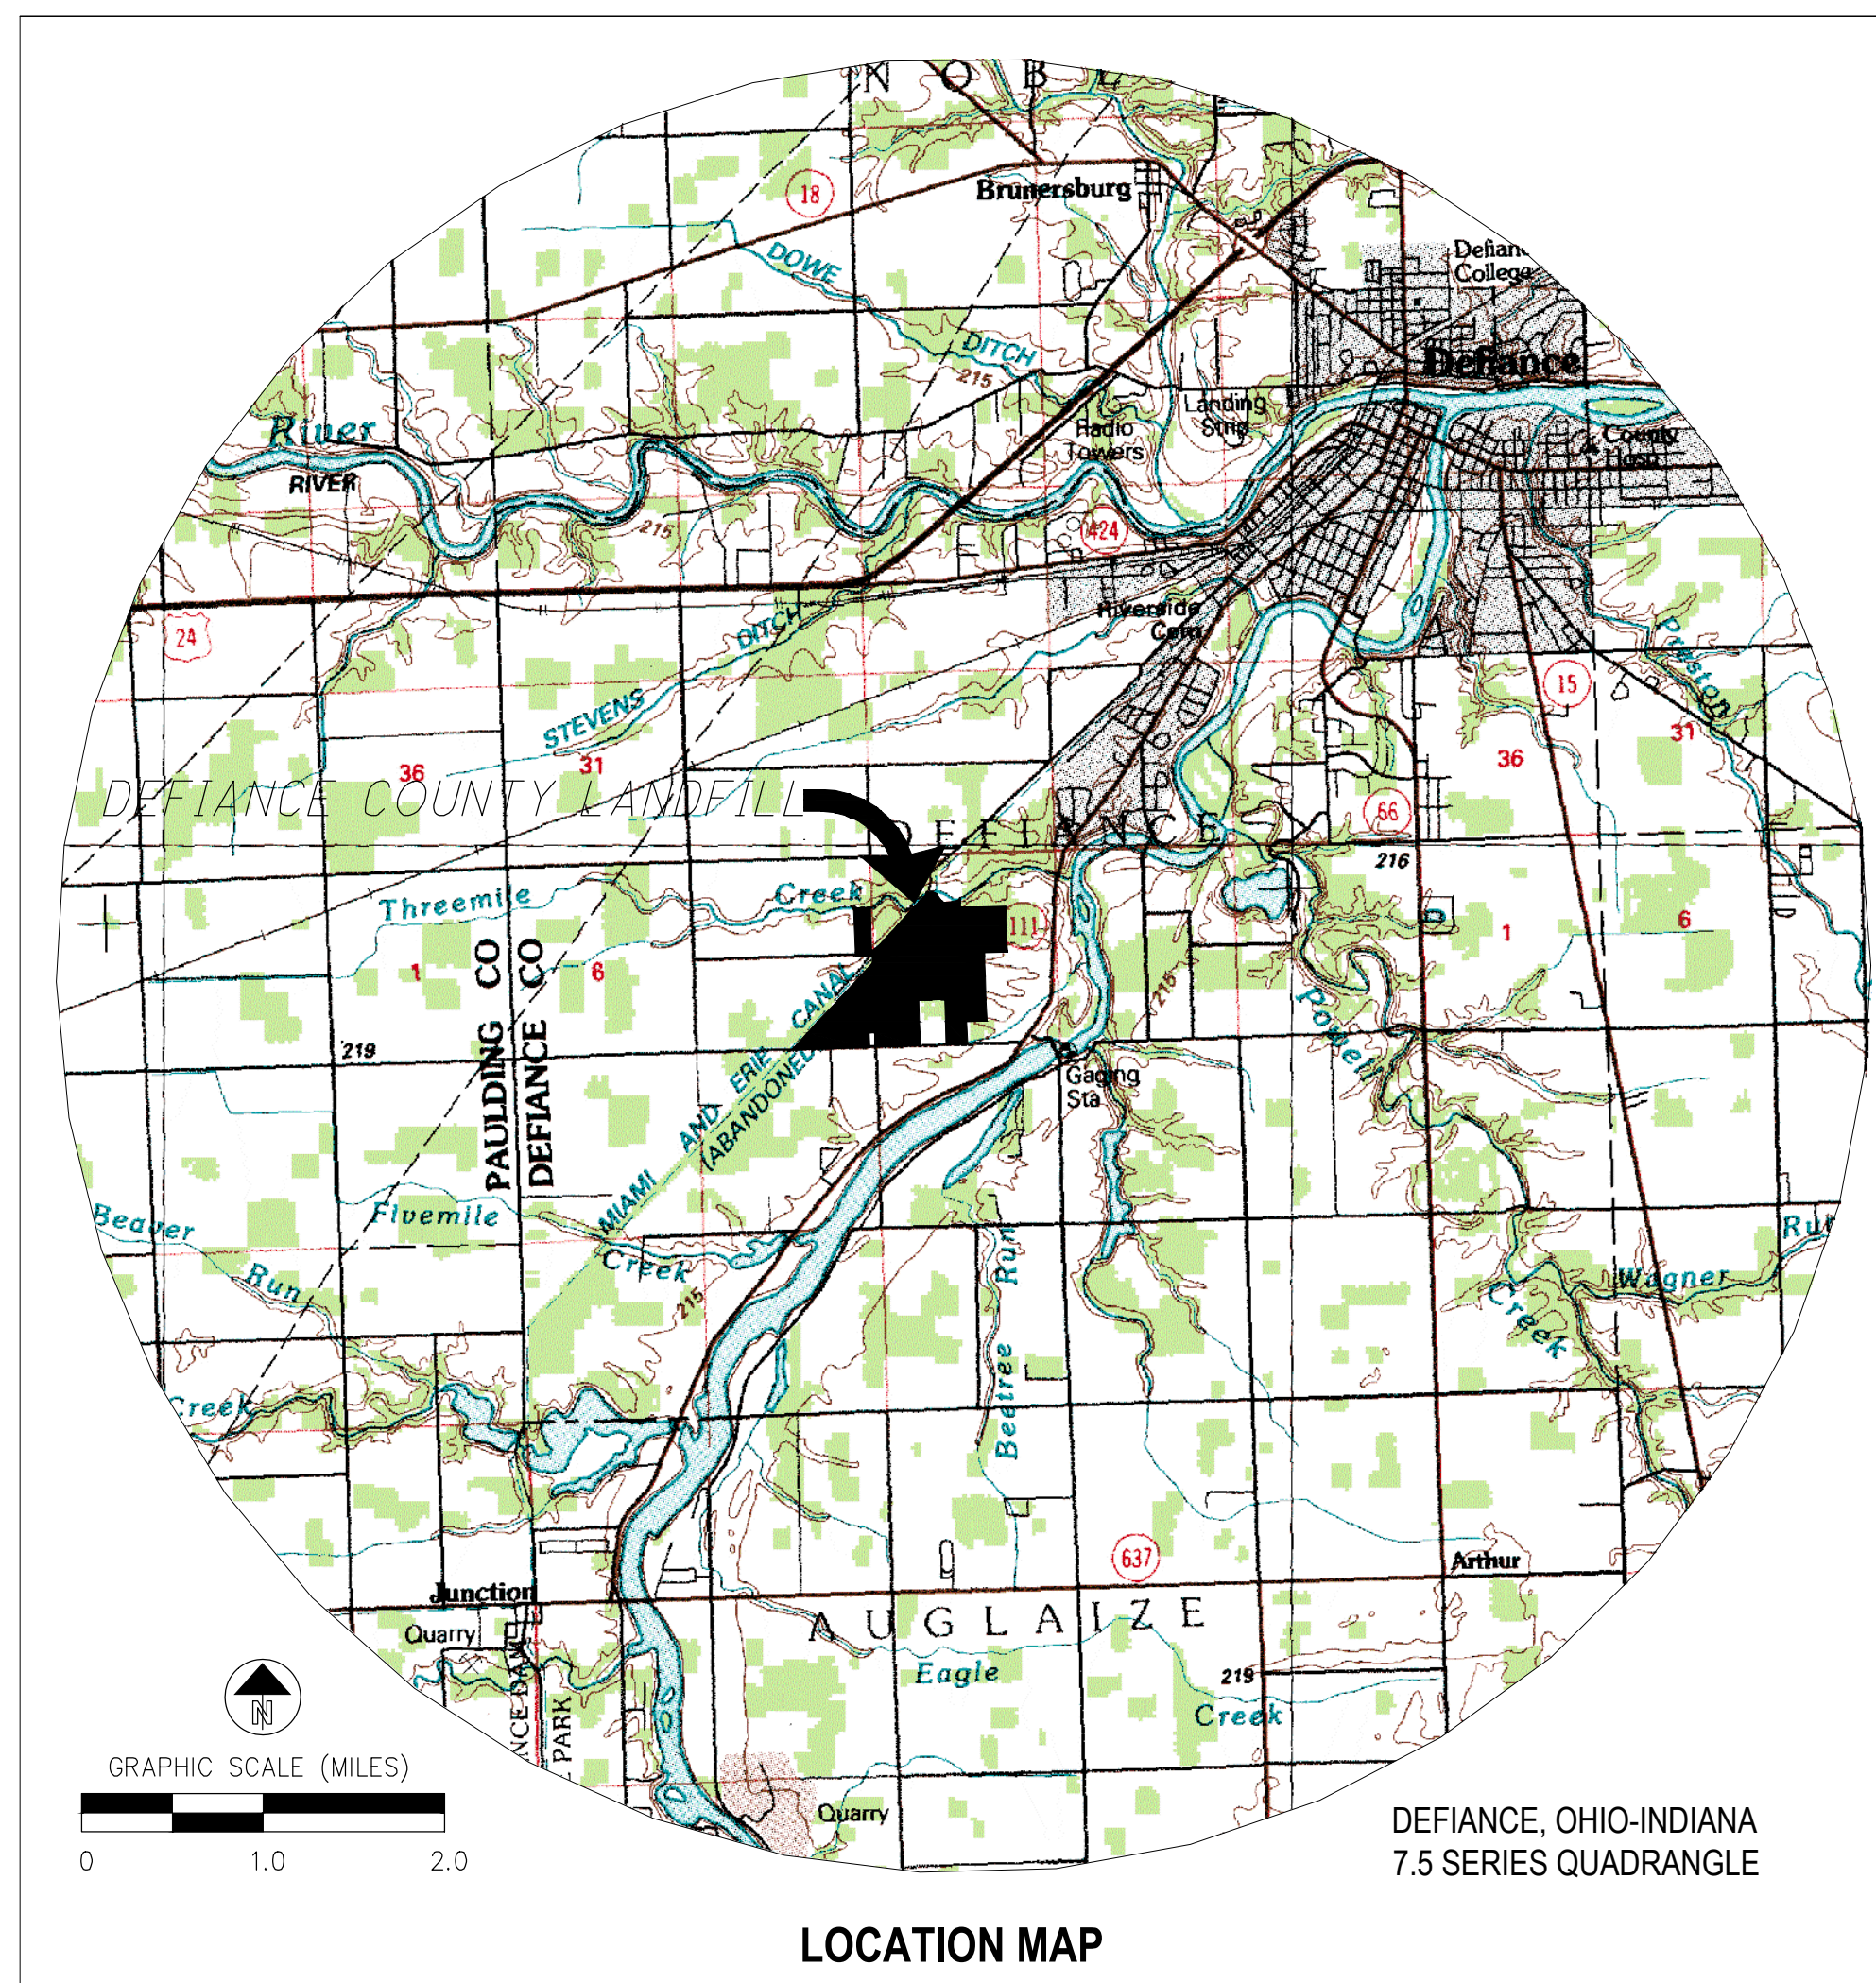

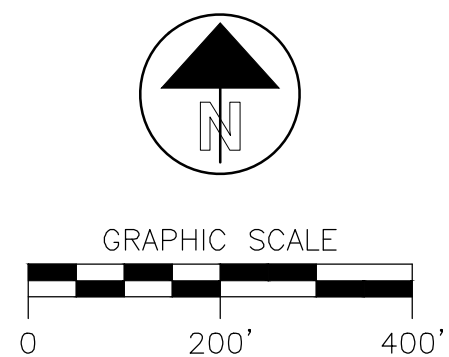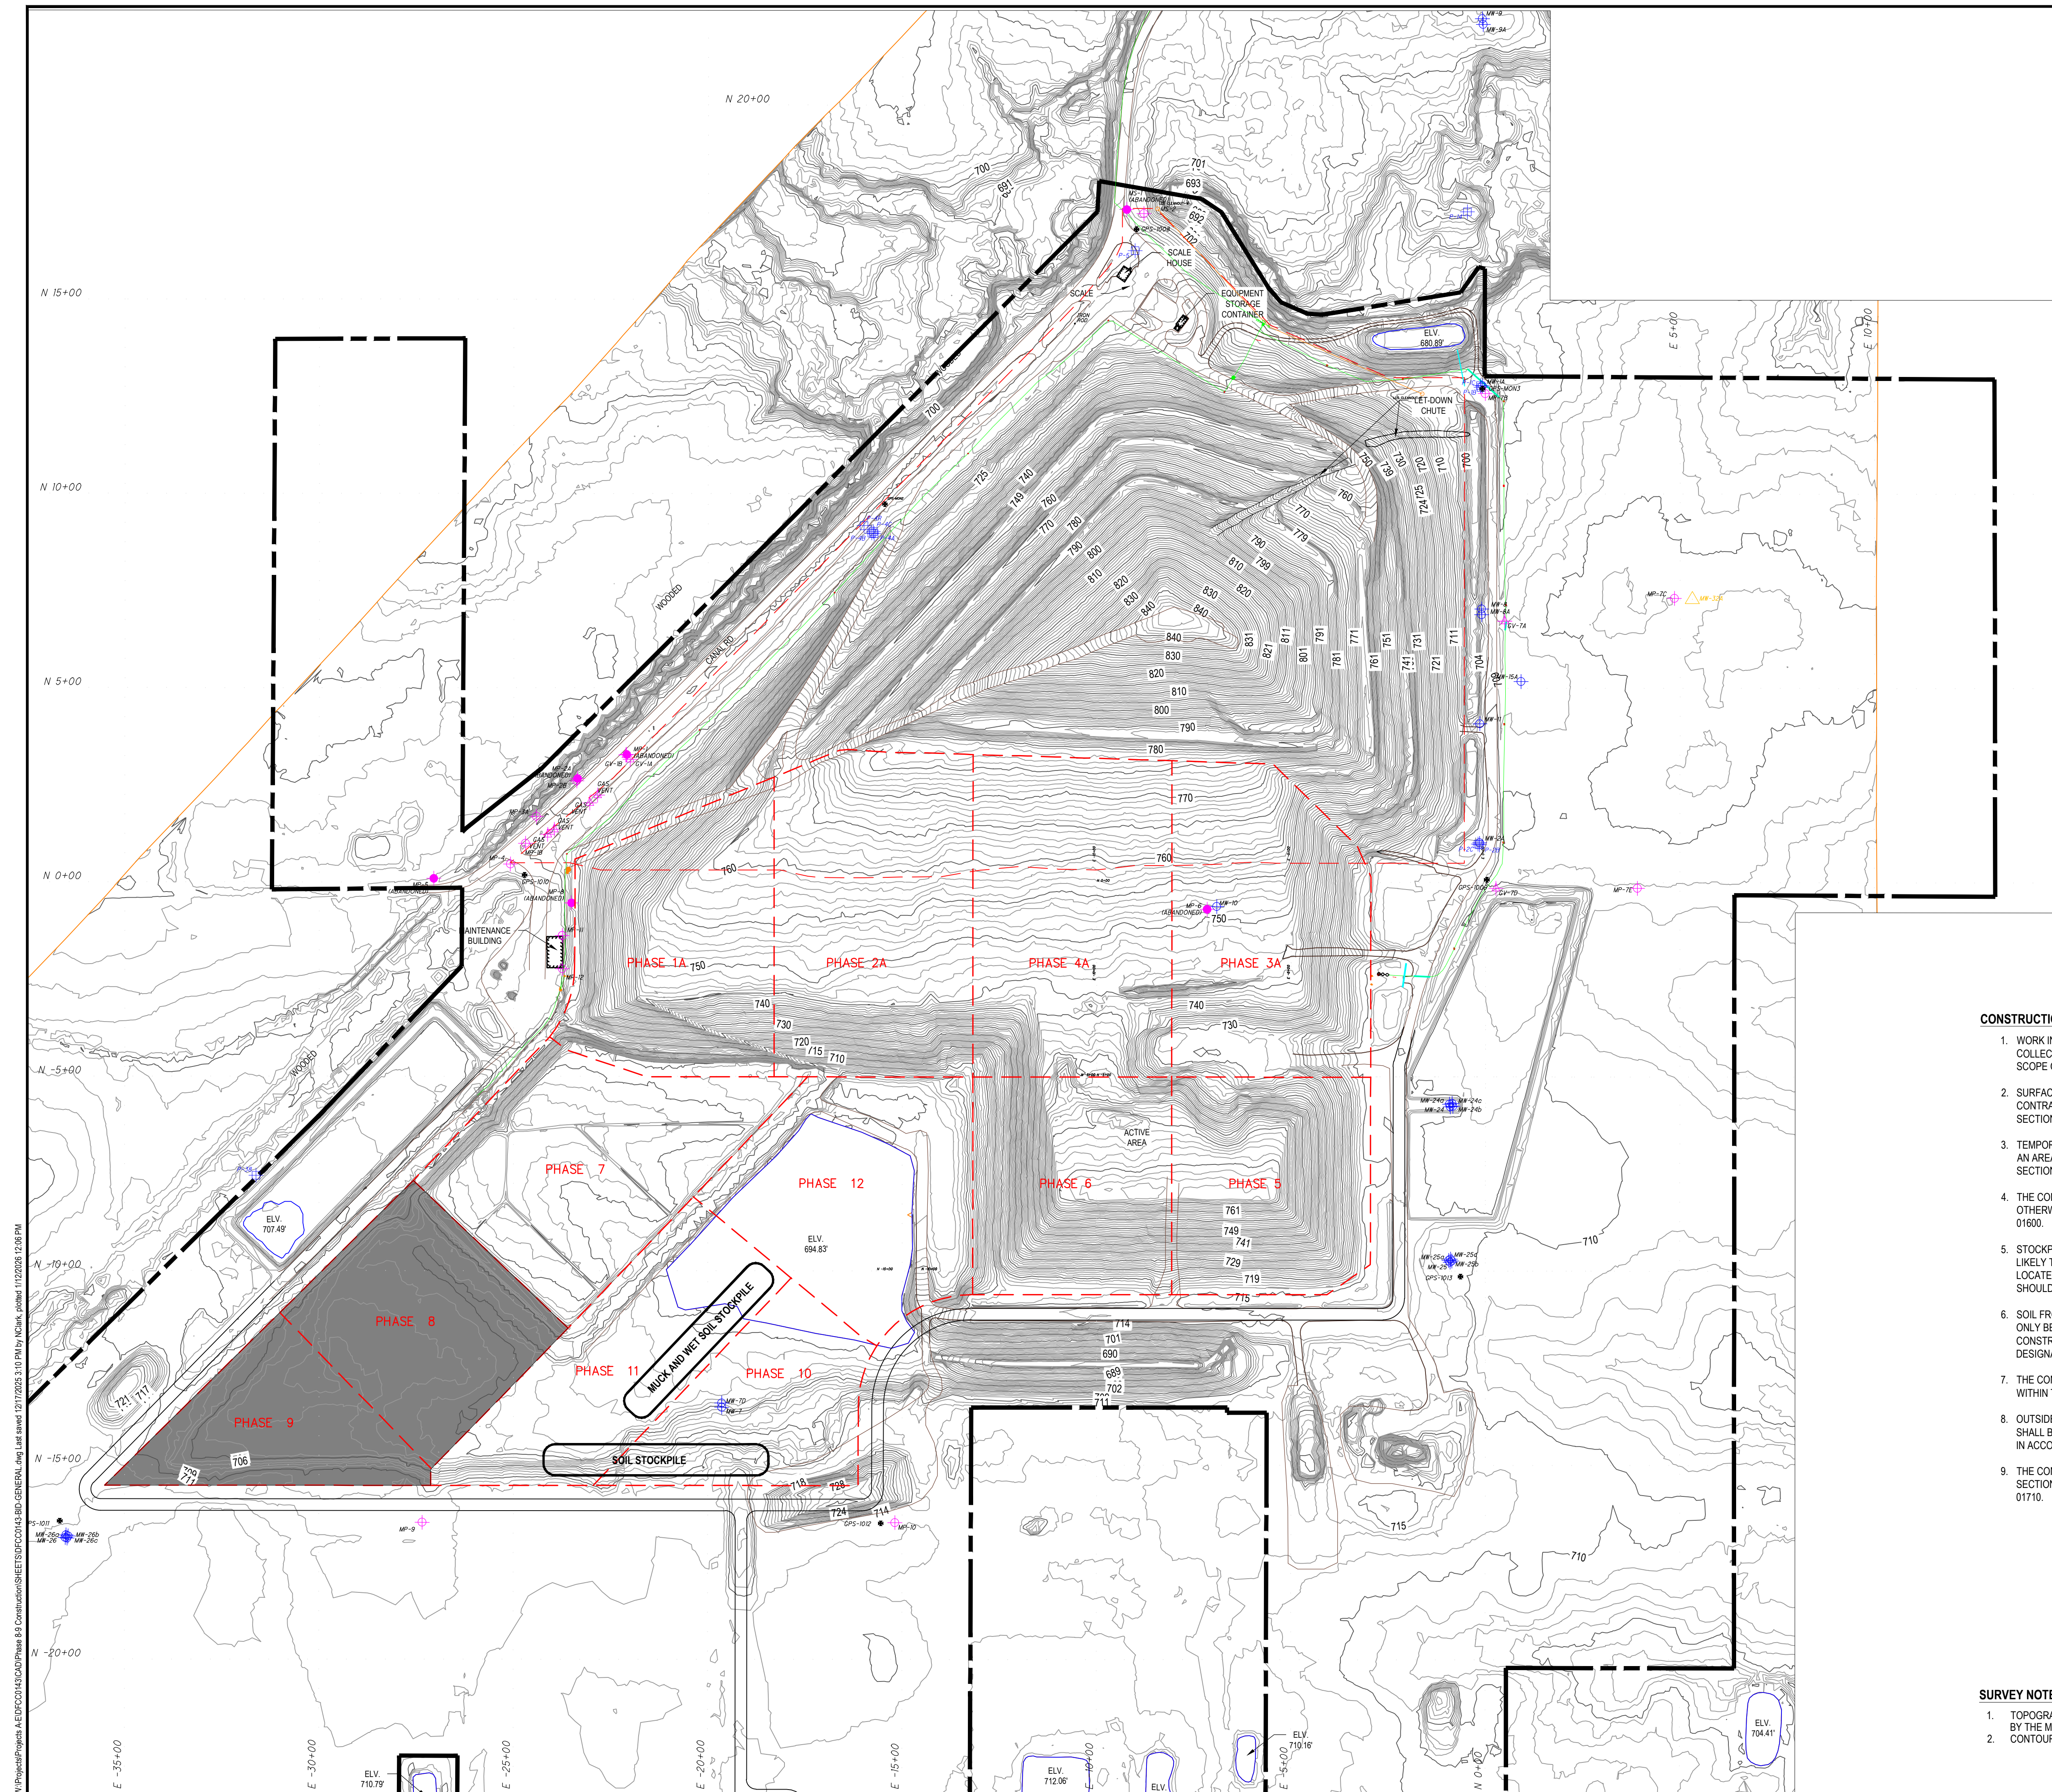

LEGEND

- | | |
|---|--|
|  | EXISTING CONTOURS |
|  | PROPERTY BOUNDARY
DEFIANCE COUNTY COMMISSIONERS |
|  | EXISTING PERIMETER FENCE |
|  | PROPOSED CONSTRUCTION LIMIT |
|  | CELL PHASE LIMIT |
|  | PHASE TRANSITION BOUNDARY |
|  | EXISTING GROUNDWATER MONITORING WELLS |
|  | EXISTING PIEZOMETER |
|  | EXISTING GAS MONITORING PROBE |
|  | EXISTING GAS VENT |
|  | GPS SURVEY BENCHMARK |
|  | EXISTING LEACHATE FORCEMAIN |

SURVEY CONTROL POINT COORDINATE TABLE

Point ID	Defiance County Landfill Coordinate System		
	NORTH	EAST	ELEVATION
GPS1008	1680.841	-898.941	709.25
GPS1009	7.734	3.318	710.26
GPS1010	18.656	-2471.890	708.69
GPS1011	-1644.084	-3666.263	712.00
GPS1012	-1645.197	-3666.263	712.00
GPS1013	-1013.685	63.892	711.86
GPS MON3	1271.294	-8.774	708.30

Point ID	State Plane Coordinate System NAV88		
	NORTH	EAST	ELEVATION
GPS1008	587253.665	1442661.244	708.17
GPS1009	587059.665	1442662.669	709.63
GPS1010	587128.196	1442662.669	707.63
GPS1011	579495.137	1439816.038	710.96
GPS1012	579438.973	1441926.814	712.77
GPS1013	580040.139	1443432.314	709.07
GPS MON3	582323.174	1443341.472	707.22

CONSTRUCTION NOTES


1. WORK INCLUDES BUT IS NOT LIMITED TO CONSTRUCTION OF COMPOSITE LINER & LEACHATE COLLECTION SYSTEM IN PHASES 8 & 9. SEE CONTRACT BID DOCUMENTS FOR COMPLETE SCOPE OF WORK.
2. SURFACE TOPOGRAPHY DEPICTING CURRENT CONDITIONS IS APPROXIMATE. THE CONTRACTOR IS RESPONSIBLE FOR HIS OWN SURVEY INFORMATION IN ACCORDANCE WITH SECTION 0150.
3. TEMPORARY CONTRACTOR FACILITIES & UTILITIES IF NECESSARY ARE TO BE LOCATED IN AN AREA ACCEPTABLE TO THE OWNER'S REPRESENTATIVE IN ACCORDANCE WITH SECTIONS 01510 & 01590.
4. THE CONTRACTOR SHALL PARK & STAGE EQUIPMENT IN DESIGNATED AREAS ONLY, UNLESS OTHERWISE SPECIFIED BY THE OWNER'S REPRESENTATIVE IN ACCORDANCE WITH SECTION 01600.
5. STOCKPILE LOCATIONS FOR EXCESS SOIL WILL BE DETERMINED BY OWNER & ENGINEER, LIKELY TO THE SOUTHEAST OF THE WORK AREA. TEMPORARY SOIL STOCKPILES SHOULD BE LOCATED IN AREAS WHERE THE SOIL IS NEEDED FOR FUTURE WORK. SOIL STOCKPILES SHOULD BE LOCATED & MAINTAINED IN ACCORDANCE WITH SECTION 02219.
6. SOIL FROM THE BORROW AREA BLOCKS CONSISTS OF PREQUALIFIED MATERIAL & SHALL ONLY BE USED IN CONSTRUCTION OF RECOMPACTED SOIL LINER. SOIL FOR OTHER CONSTRUCTION SHALL BE TAKEN FROM EXCESS SOIL STOCKPILES OR OTHER AREAS DESIGNATED BY THE ENGINEER.
7. THE CONTRACTOR IS RESPONSIBLE FOR IMPLEMENTING ENVIRONMENTAL CONTROLS WITHIN THE CONSTRUCTION LIMITS IN ACCORDANCE WITH SECTION 01600.
8. OUTSIDE THE LIMITS OF CONSTRUCTION ALL AREAS DISTURBED BY THE CONTRACTOR SHALL BE RESTORED TO THE CONDITIONS PRESENT PRIOR TO THE CONTRACTOR'S ARRIVAL IN ACCORDANCE WITH SECTION 0150.
9. THE CONTRACTOR SHALL PERFORM WORK CLOSE OUT ACTIVITIES IN ACCORDANCE WITH SECTION 01700 & MAINTAIN PROJECT RECORD DOCUMENTS IN ACCORDANCE WITH SECTION 01710.

SURVEY NOTES

1. TOPOGRAPHIC INFORMATION IS BASED ON AN AERIAL SURVEY FLOWN ON 10-20-2023 BY THE MANNIK & SMITH GROUP, INC.
2. CONTOUR INTERVAL = 1 FOOT.

[illegible]

W:\Projects\Projects\A-EDFC0143C\DWG\Phase 8-9 Construction\Sheets\EDFC0143-BD-C.dwg, Last saved: 12/17/2025 3:12 PM by NChitt, plotted: 11/20/2025 12:07 PM

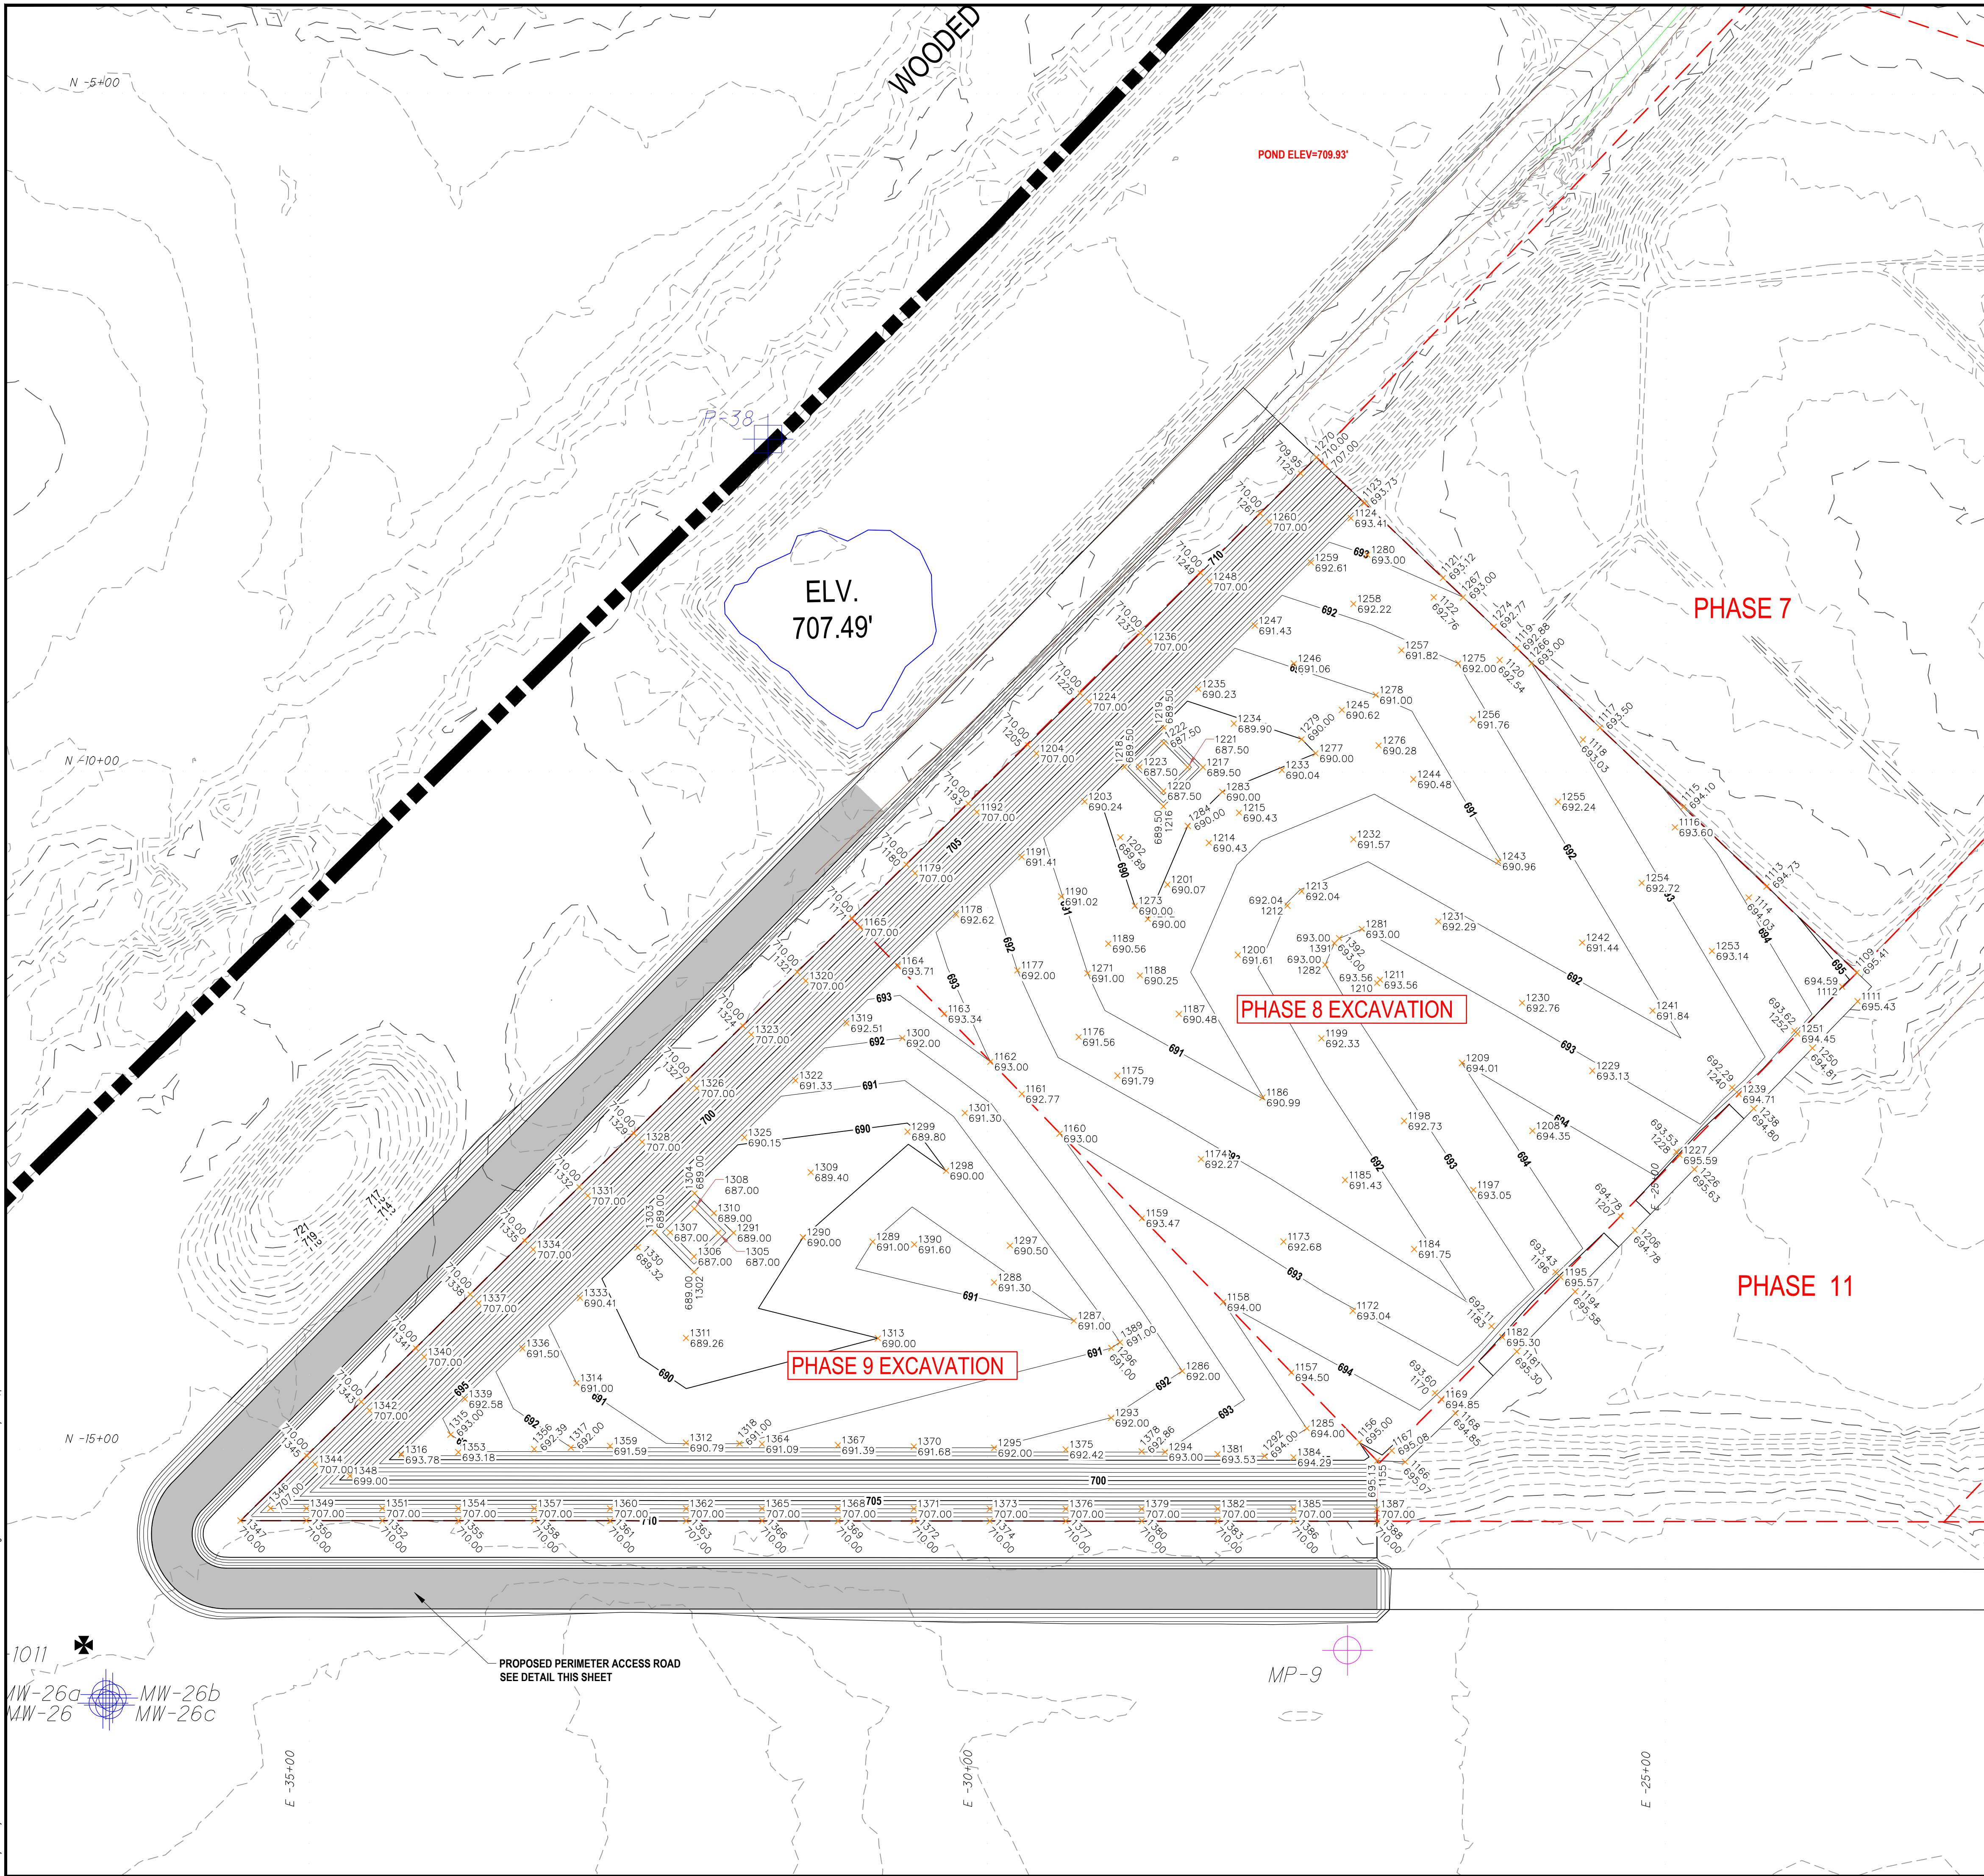


LEGEND

- 710 EXISTING CONTOURS
- 710 PROPOSED EXCAVATION CONTOURS
- PROPOSED EXCAVATION SPOT ELEVATION
- PROPERTY BOUNDARY
DEFIANCE COUNTY COMMISSIONERS
- EXISTING PERIMETER FENCE
- PROPOSED CONSTRUCTION LIMIT
- CELL PHASE LIMIT
- PHASE TRANSITION BOUNDARY
- MP-11 EXISTING GROUNDWATER MONITORING WELLS
- P-29 EXISTING PIEZOMETER
- MP-24 EXISTING GAS MONITORING PROBE
- GAS VENT
- GPS SURVEY BENCHMARK
- FM EXISTING LEACHATE FORCEMAIN

CONSTRUCTION NOTES

- SURFACE TOPOGRAPHY DEPICTING CURRENT CONDITIONS IS APPROXIMATE. THE CONTRACTOR IS RESPONSIBLE FOR HIS OWN SURVEY INFORMATION IN ACCORDANCE WITH SECTION 01050.
- THE CONTRACTOR IS RESPONSIBLE FOR IMPLEMENTING ENVIRONMENTAL CONTROLS WITHIN THE CONSTRUCTION LIMITS IN ACCORDANCE WITH SECTION 01560.
- THE CONTRACTOR SHALL IMPLEMENT EROSION & SURFACE WATER CONTROL MEASURES TO THE DEGREE NECESSARY TO PROMOTE & MAINTAIN DRAINAGE TO THE SOUTHEAST CORNER OF PHASES 10 AND 12.
- THE CONTRACTOR SHALL REGRADE PHASES 8 & 9 TO MEET LINES & GRADES SHOWN FOR PHASE 8 & 9 SUBGRADE. STRUCTURAL FILL SHALL BE ADDED AS NECESSARY IN ACCORDANCE WITH SECTION 02214. PHASE 8 & 9 SHALL BE COMPLETED IN ACCORDANCE WITH SECTION 02216. PHASE 8 & 9 SHALL BE PREPARED TO RECEIVE RECOMPACTED SOIL BARRIER IN ACCORDANCE WITH SECTION 02215. CELL FLOOR IS TO BE GRADED AS SHOWN. CELL SIDESLOPES ARE TO BE GRADED AT 3H:1V.
- REFER TO SHEET 13A FOR A TABLE OF EXCAVATION CONSTRUCTION POINTS GRAPHICALLY SHOWN ON THIS SHEET.
- PREQUALIFIED SOIL TO BE USED FOR PHASE 8 & 9 RECOMPACTED SOIL LINER IS LOCATED WITHIN PHASE 8 & 9 LIMITS. EXCESS SOIL IN PHASE 8 & 9 SHALL BE PLACED IN THE PREQUALIFIED SOIL STOCKPILE. IF ADDITIONAL SOIL IS REQUIRED TO COMPLETE THE PHASE 8 & 9 RECOMPACTED SOIL BARRIER, NOTIFY THE ENGINEER AS SOON AS POSSIBLE.
- THE CONTRACTOR SHALL OBTAIN THE COA CONSULTANT APPROVAL OF THE ENGINEERED SUBGRADE FOR PHASE 8 & 9 VIA ACCEPTABLE PROOF-ROLLING OF THE SUBGRADE BEFORE CONSTRUCTION OF THE RECOMPACTED CLAY LINER BEGINS.

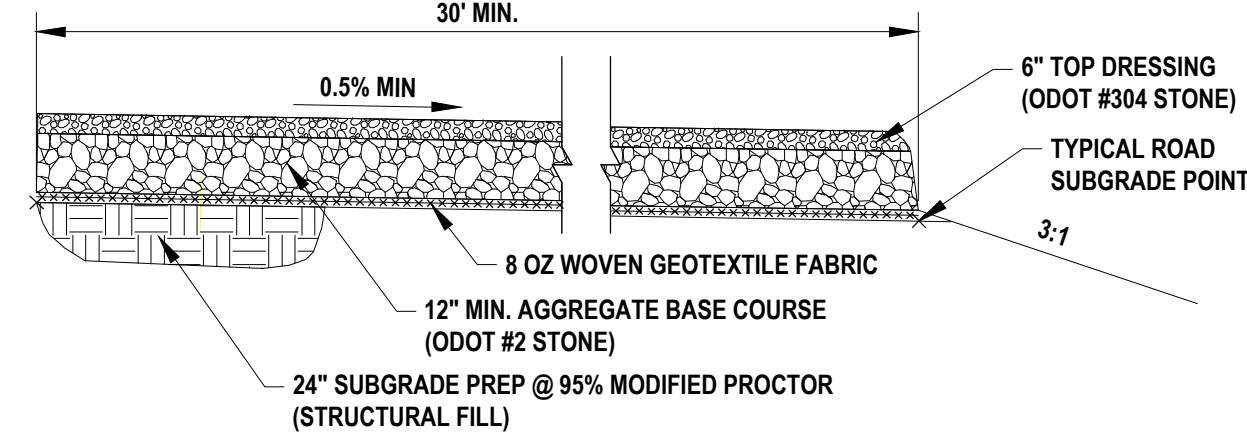

PERIMETER ROAD AND CUSTOMER ACCESS

SCALE: NTS
NOTE: MINIMUM SEAMS FOR 80Z WOVEN FABRIC TO BE 6\"/>

SURVEY NOTES

- TOPOGRAPHIC INFORMATION IS BASED ON AN AERIAL SURVEY FLOWN ON 10-20-2025 BY THE MANNIK & SMITH GROUP, INC.
- CONTOUR INTERVAL = 1 FOOT.

NO. DATE BY DESCRIPTION

 
1800 INDIAN WOOD CIRCLE
MAINEE, OH 43537
TEL: 419.891.2222
FAX: 419.891.1555
PROJECT DATE: NOVEMBER 2025
PROJECT NO.: DFCD0143
DRAWN BY: SRG
CHECKED BY: KCD

TECHNICAL SKILL
CREATIVE SPIRIT.
Mannik & Smith Group
www.MannikSmithGroup.com

PREPARED FOR
DEFIANCE COUNTY
BOARD OF
COMMISSIONERS
500 COURT STREET
DEFIANCE, OHIO 43512

SITE IMPROVEMENT PLAN FOR
DEFIANCE COUNTY
LANDFILL
13207 CANAL ROAD
DEFIANCE, OHIO 43512

EXCAVATION & GRADING
PLAN



- ### CONSTRUCTION NOTES


- Mannik
Smith
GROUP**
- TECHNICAL SKILL.
CREATIVE SPIRIT.
- www.MannikSmithGroup.com

- SITE IMPROVEMENT PLAN FOR
DEFIANCE COUNTY
LANDFILL
13207 CANAL ROAD
DEFIANCE, OHIO 43512**

**LEACHATE DRAINAGE
LAYER PLAN**


- ## SURVEY NOTES

1. TOPOGRAPHIC INFORMATION IS BASED ON AN AERIAL SURVEY FLOWN ON 10-20-2023 BY THE MANNIK & SMITH GROUP, INC.
2. CONTOUR INTERVAL = 1 FOOT.

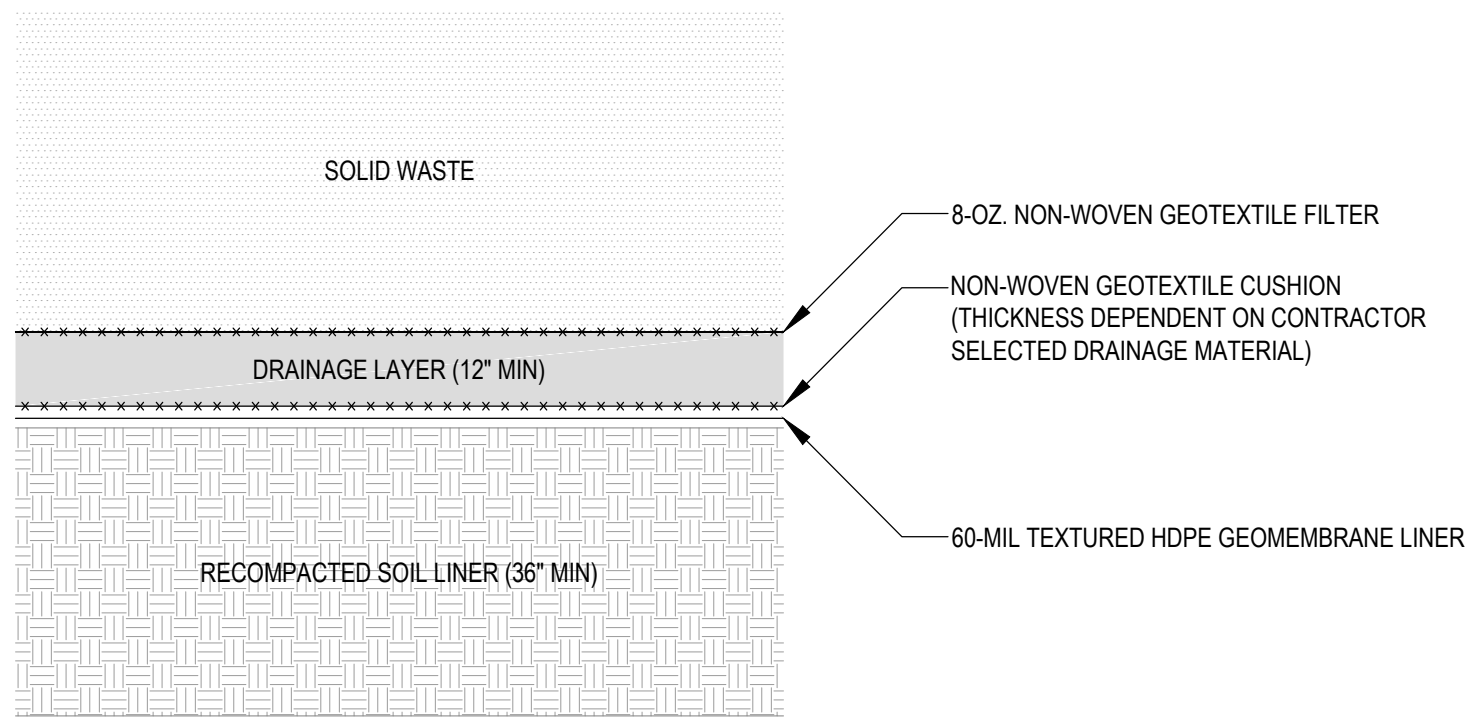


1
7 **COMPOSITE LINER SYSTEM**
SCALE: N.T.S.

- NOTES:
1. DRAINAGE LAYER SHALL BE AGGREGATE WITH A MINIMUM PERMEABILITY OF 1.0 CM/SEC.
 2. DRAINAGE LAYER AGGREGATE SHALL HAVE LESS THAN 5% LOSS WHEN TESTED FOR CARBONATE CONTENT USING ASTM D 3042 AT PH OF 4.0.
 3. DRAINAGE LAYER AGGREGATE SHALL CONTAIN LESS THAN 5% FINES PASSING #200 SIEVE PER ASTM C 136.

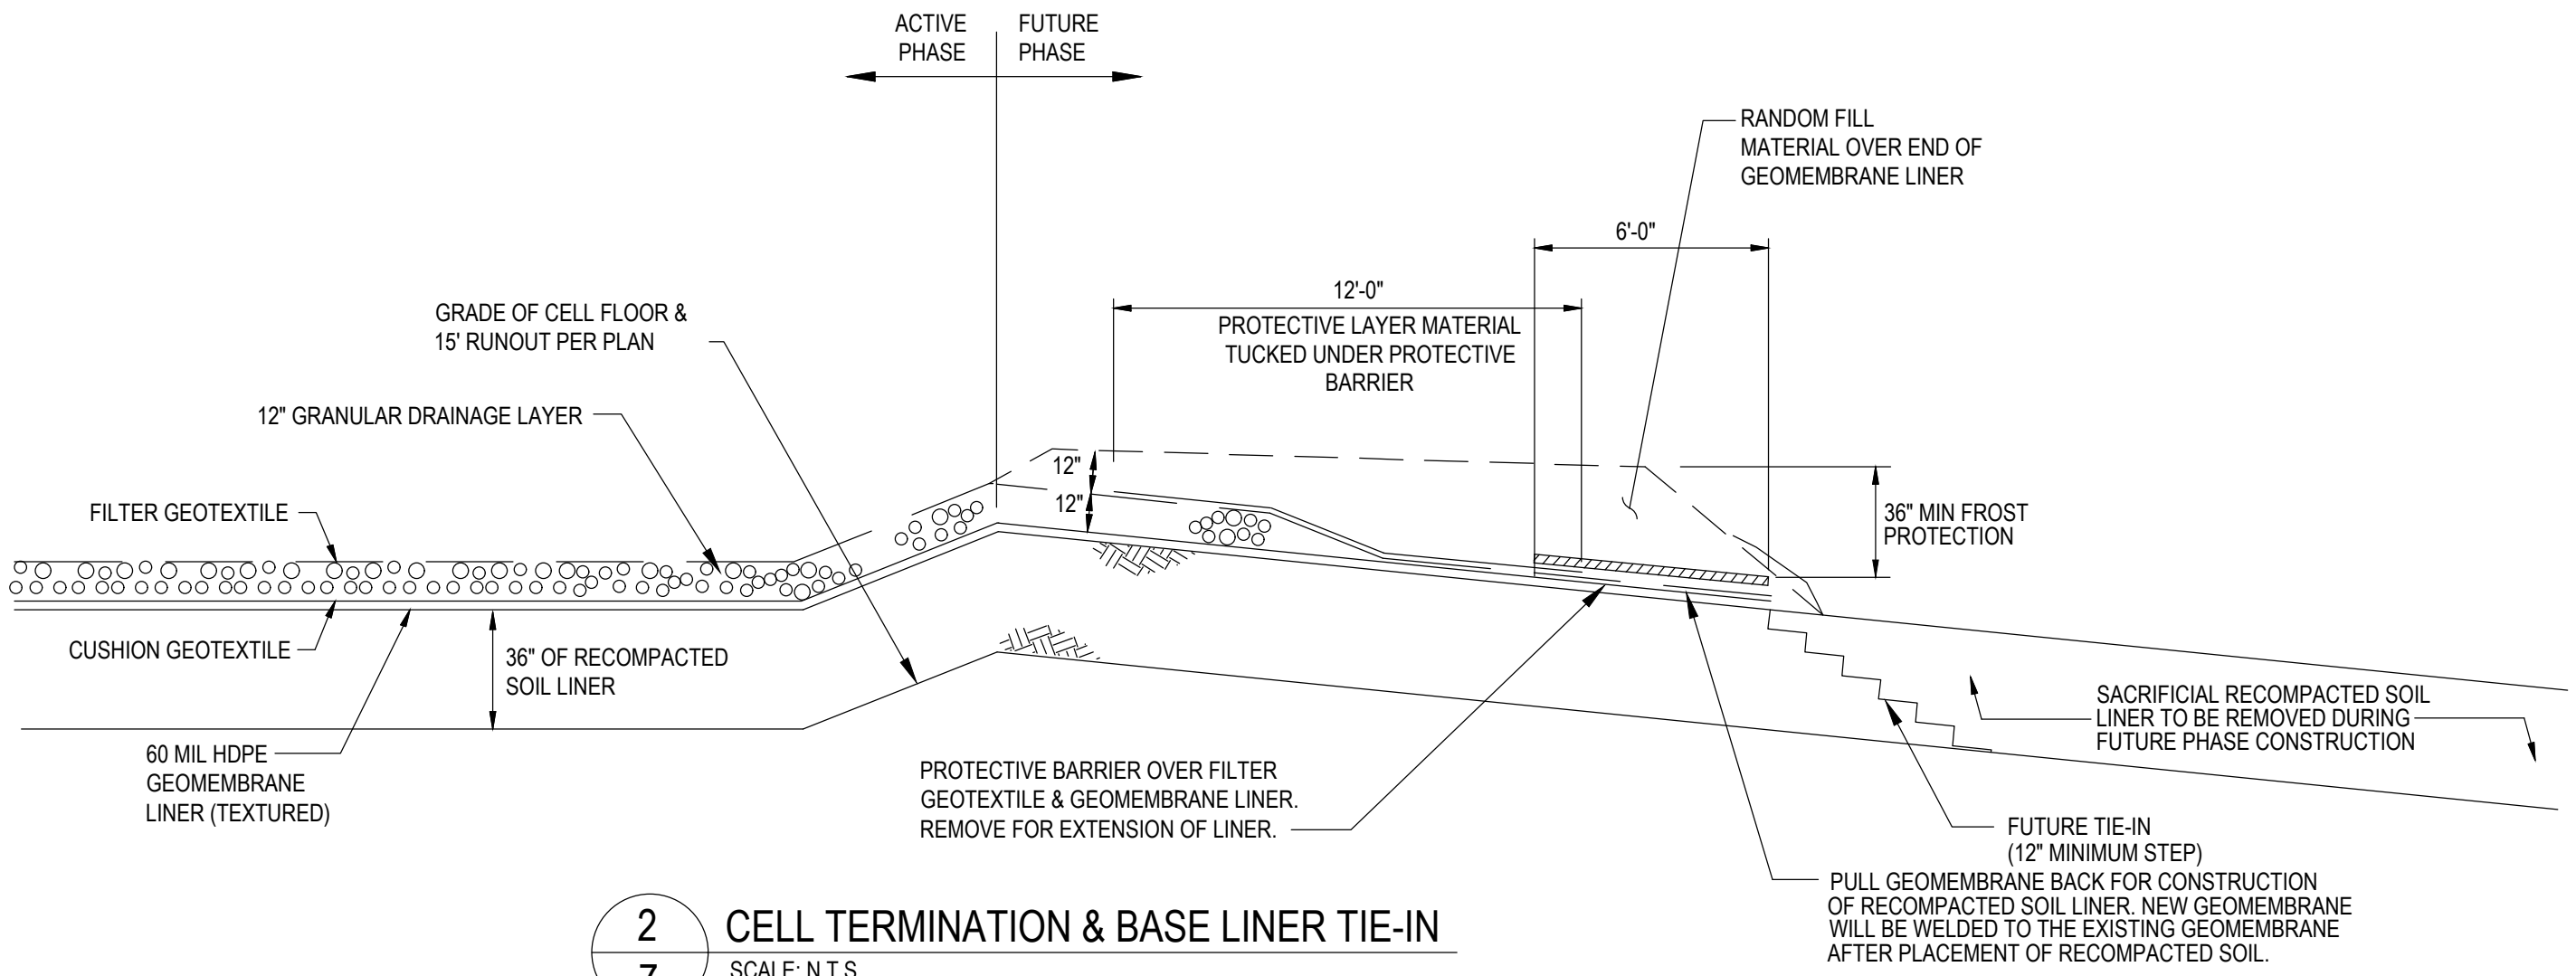


2
7 **CELL TERMINATION & BASE LINER TIE-IN**
SCALE: N.T.S.

- NOTES:
1. PROTECTIVE BARRIER MATERIAL IS AN ADDITIONAL LAYER OF GEOTEXTILE OR GEOMEMBRANE PLACED ON TOP OF THE FILTER GEOTEXTILE TO PROTECT & LIMIT CONTAMINATION OF FILTER LAYER.
 2. PLYWOOD PLACED ON SOUTHERN TERMINATION

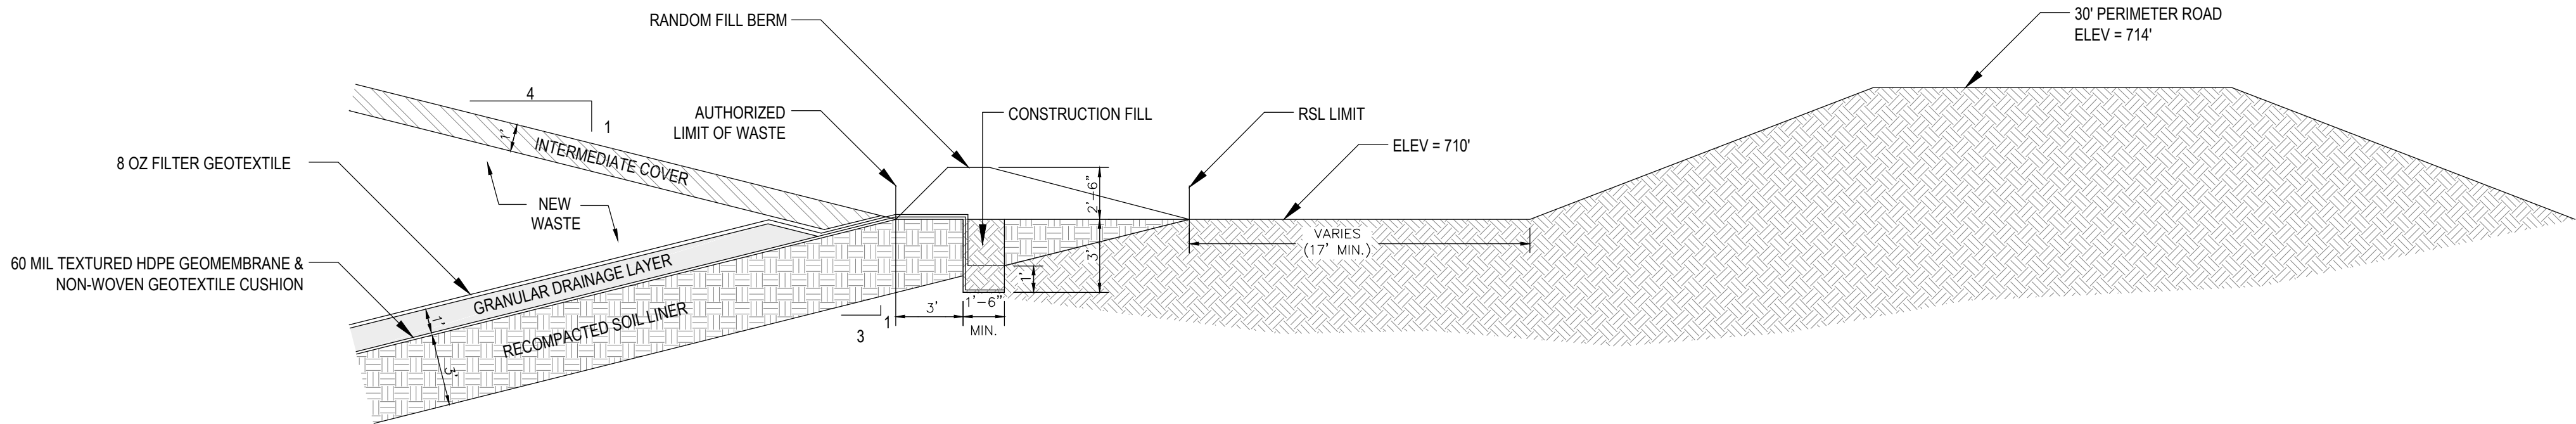


3
7 **SIDESLOPE ANCHOR TRENCH**
SCALE: N.T.S.

- NOTE:
- PERIMETER ROAD EARTHWORK NORTH OF PHASE 8 PARTIALLY COMPLETED DURING PREVIOUS PHASE 7 CONSTRUCTION

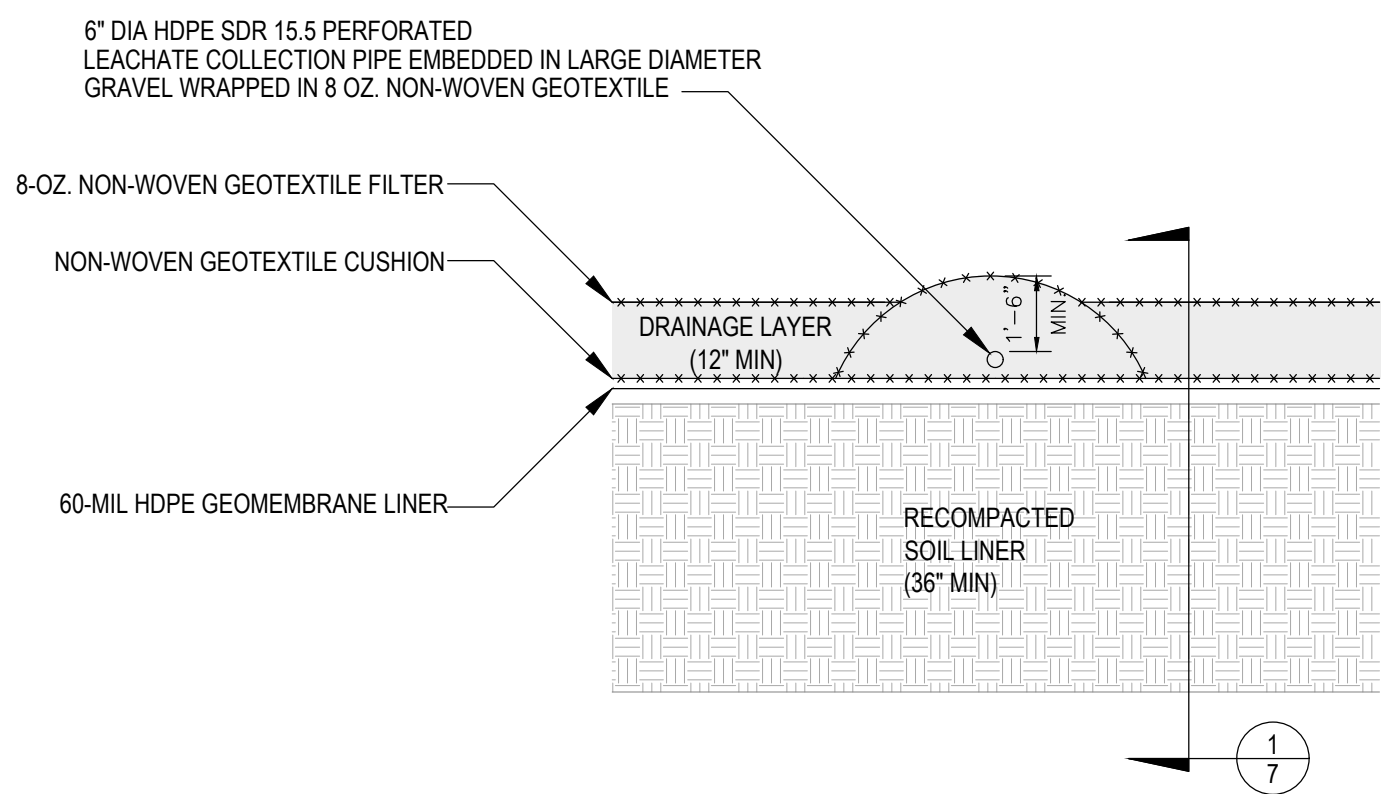


4
7 **TYPICAL BOTTOM LINER LCS PIPE DETAIL**
SCALE: N.T.S.

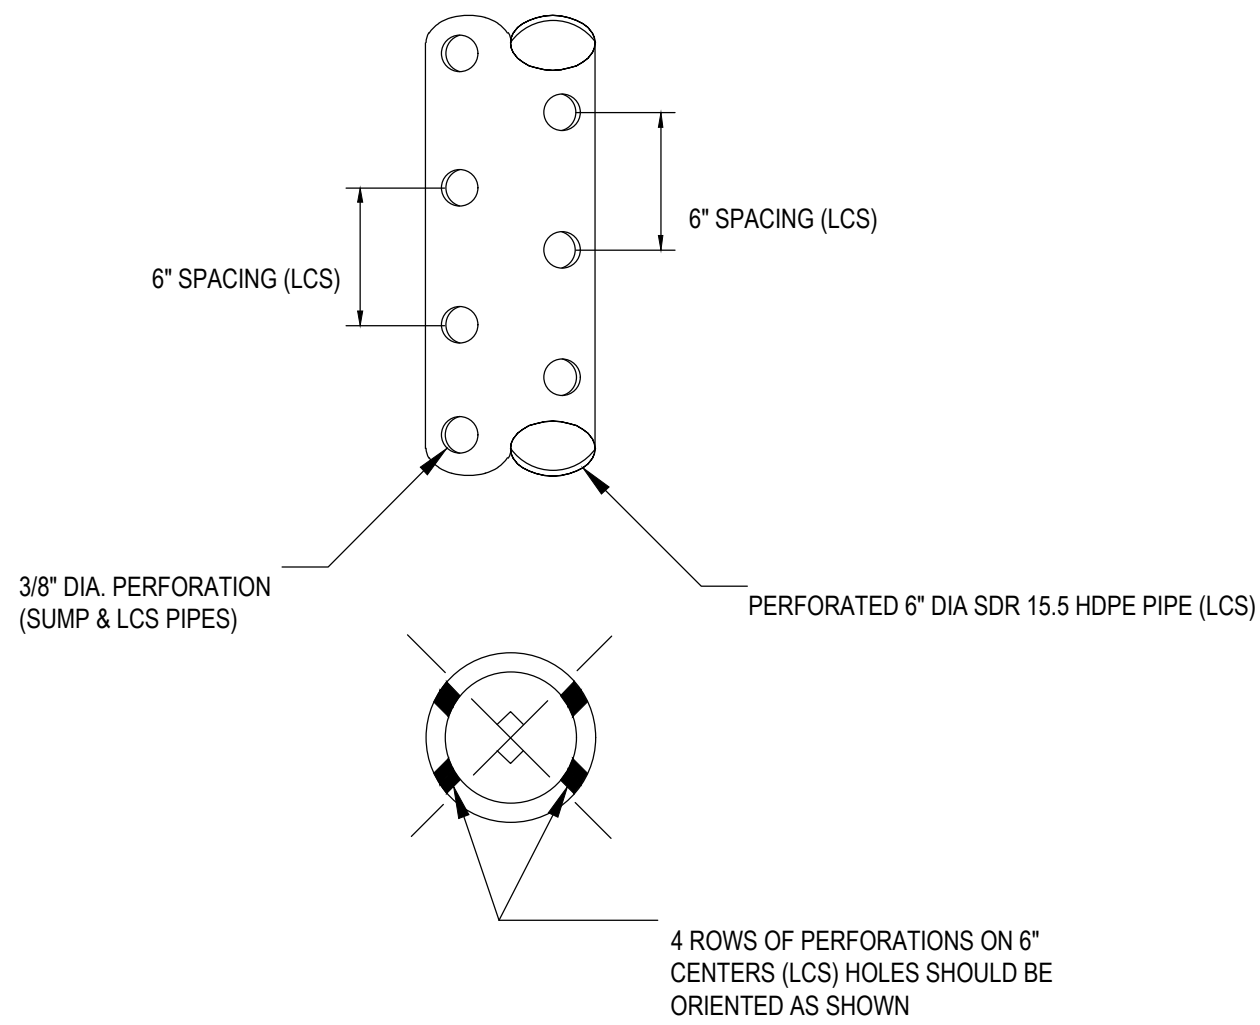

5
7 **LCS PERFORATED PIPE**
SCALE: N.T.S.

- NOTE:
- PERFORATED PIPES SHALL BE FITTED WITH A PIPE SOCK PRIOR TO PLACEMENT OF BACKFILL.

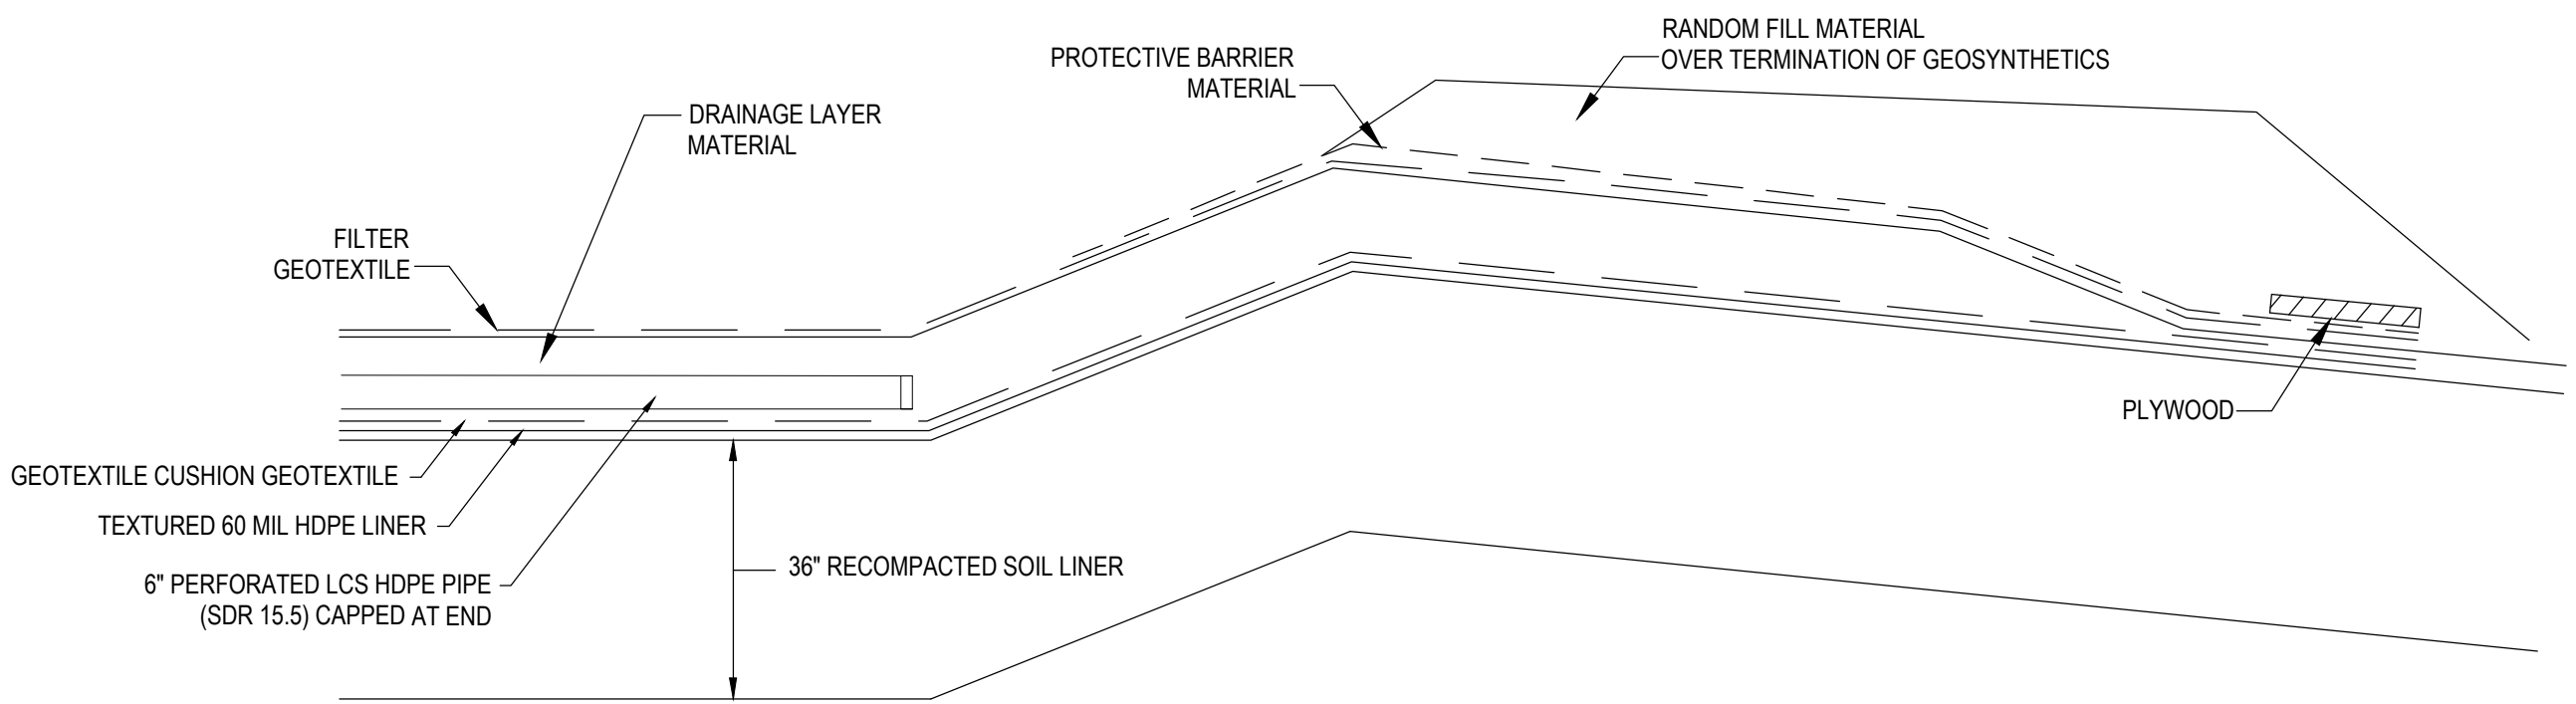

6
7 **PIPE TERMINATION DETAIL**
SCALE: N.T.S.

- NOTES:
1. PROTECTIVE BARRIER MATERIAL IS AN ADDITIONAL LAYER OF GEOTEXTILE OR GEOMEMBRANE PLACED ON TOP OF THE FILTER GEOTEXTILE TO PROTECT AND LIMIT CONTAMINATION OF FILTER LAYER.

DESCRIPTION

NO. DATE BY

1800 INDIANWOOD CIRCLE
MAYNEE, OH 43537
TEL: 419.891.2222
FAX: 419.891.1555


PROJECT DATE: NOVEMBER 2025
PROJECT NO.: DF-00143
DRAWN BY: SRG
CHECKED BY: KCD




PREPARED FOR
DEFIANCE COUNTY
BOARD OF
COMMISSIONERS
500 COURT STREET
DEFIANCE, OHIO 43512

SITE IMPROVEMENT PLAN FOR
DEFIANCE COUNTY
LANDFILL
13207 CANAL ROAD
DEFIANCE, OHIO 43512


DETAILS - LINER SYSTEM

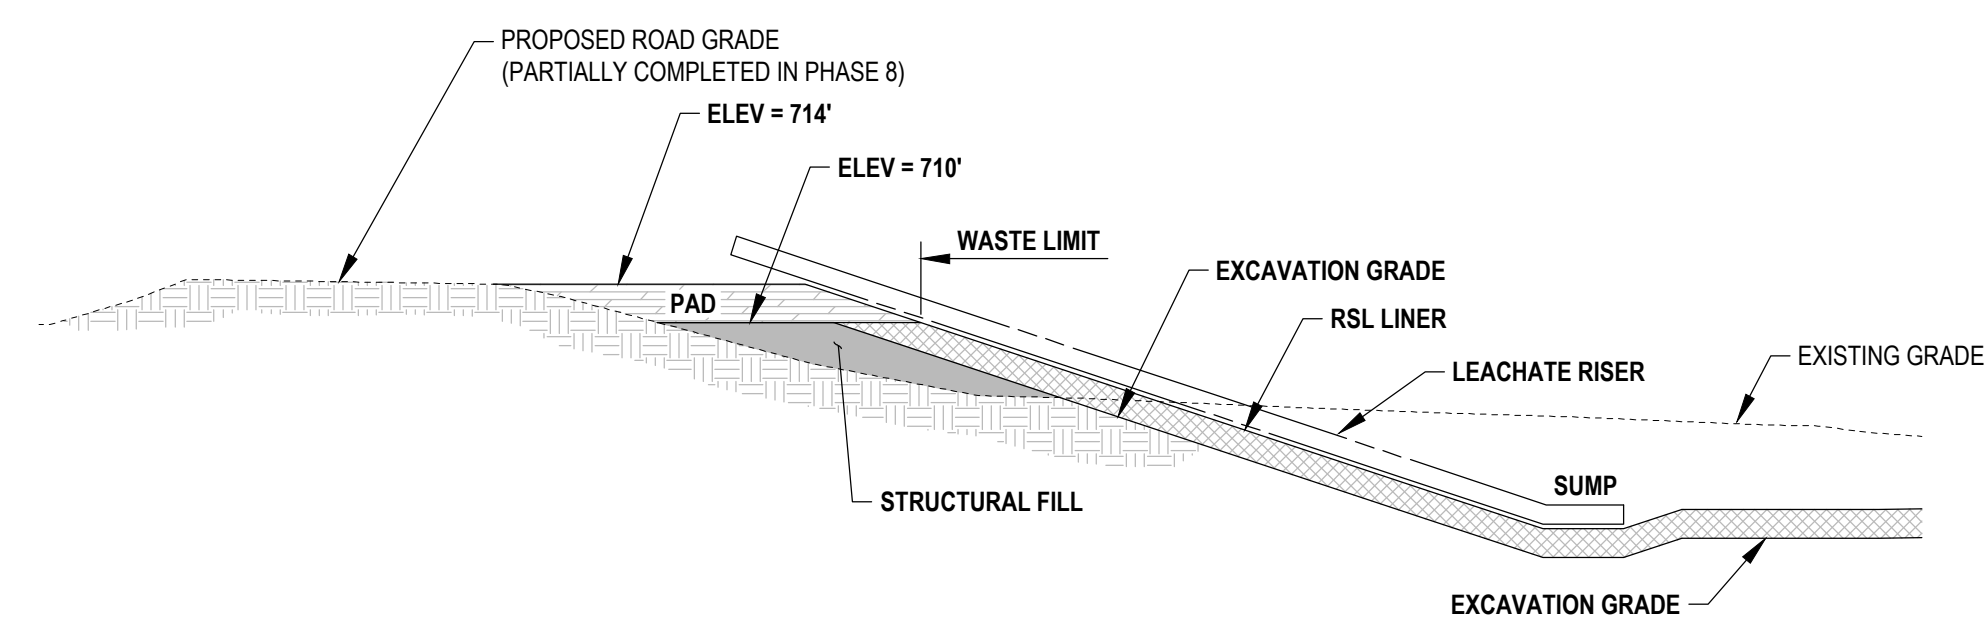

9 CELL CROSS SECTION @ SUMP
8 SCALE: N.T.S.


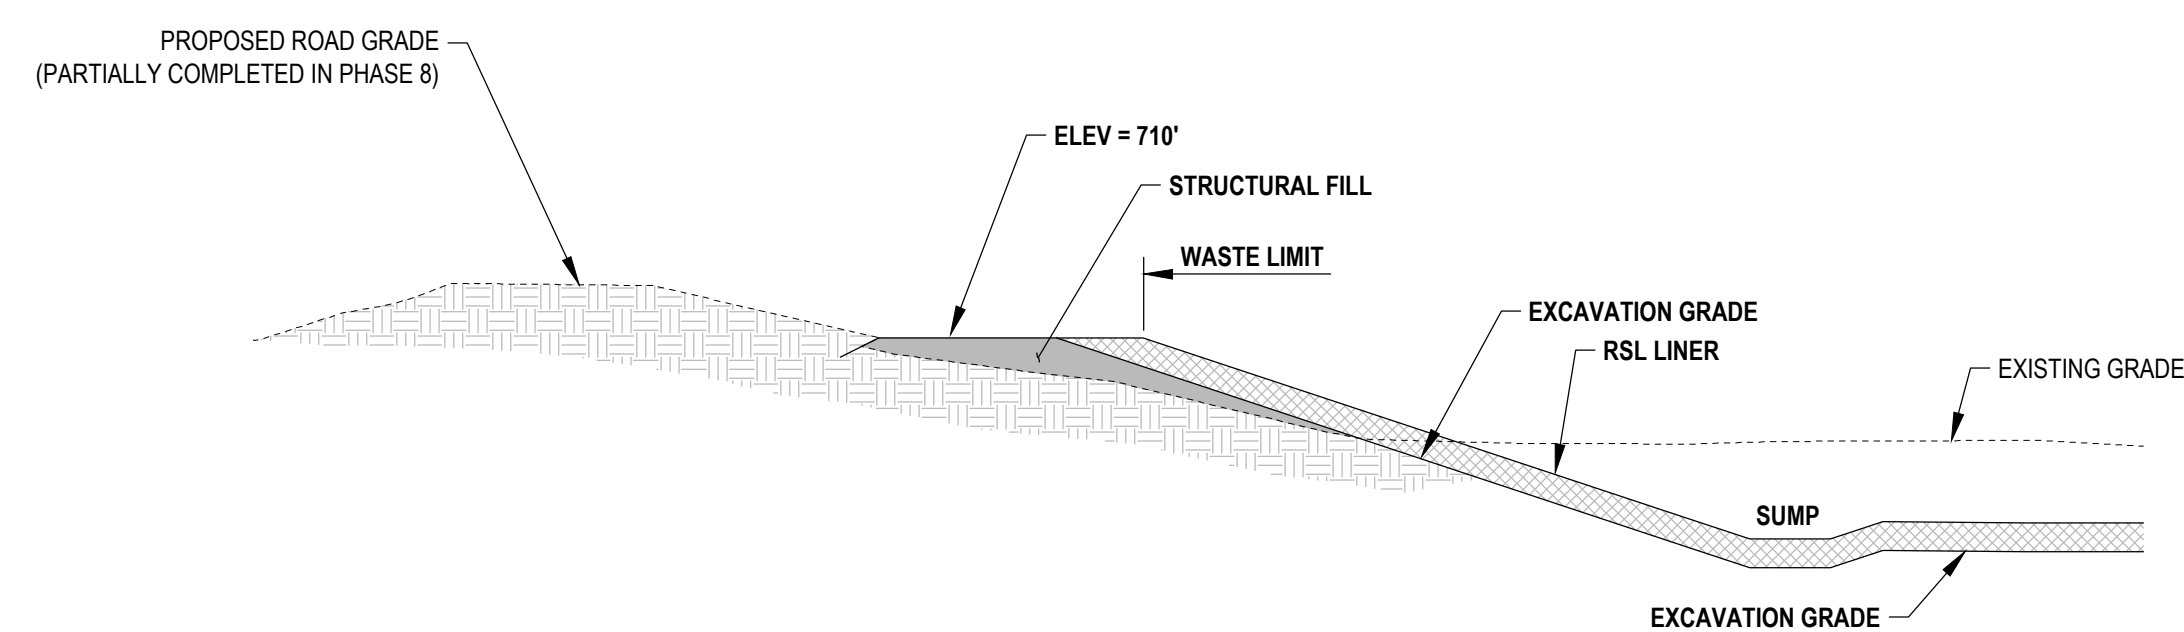



10 CELL CROSS SECTION OUTSIDE OF SUMP
8 SCALE: N.T.S.

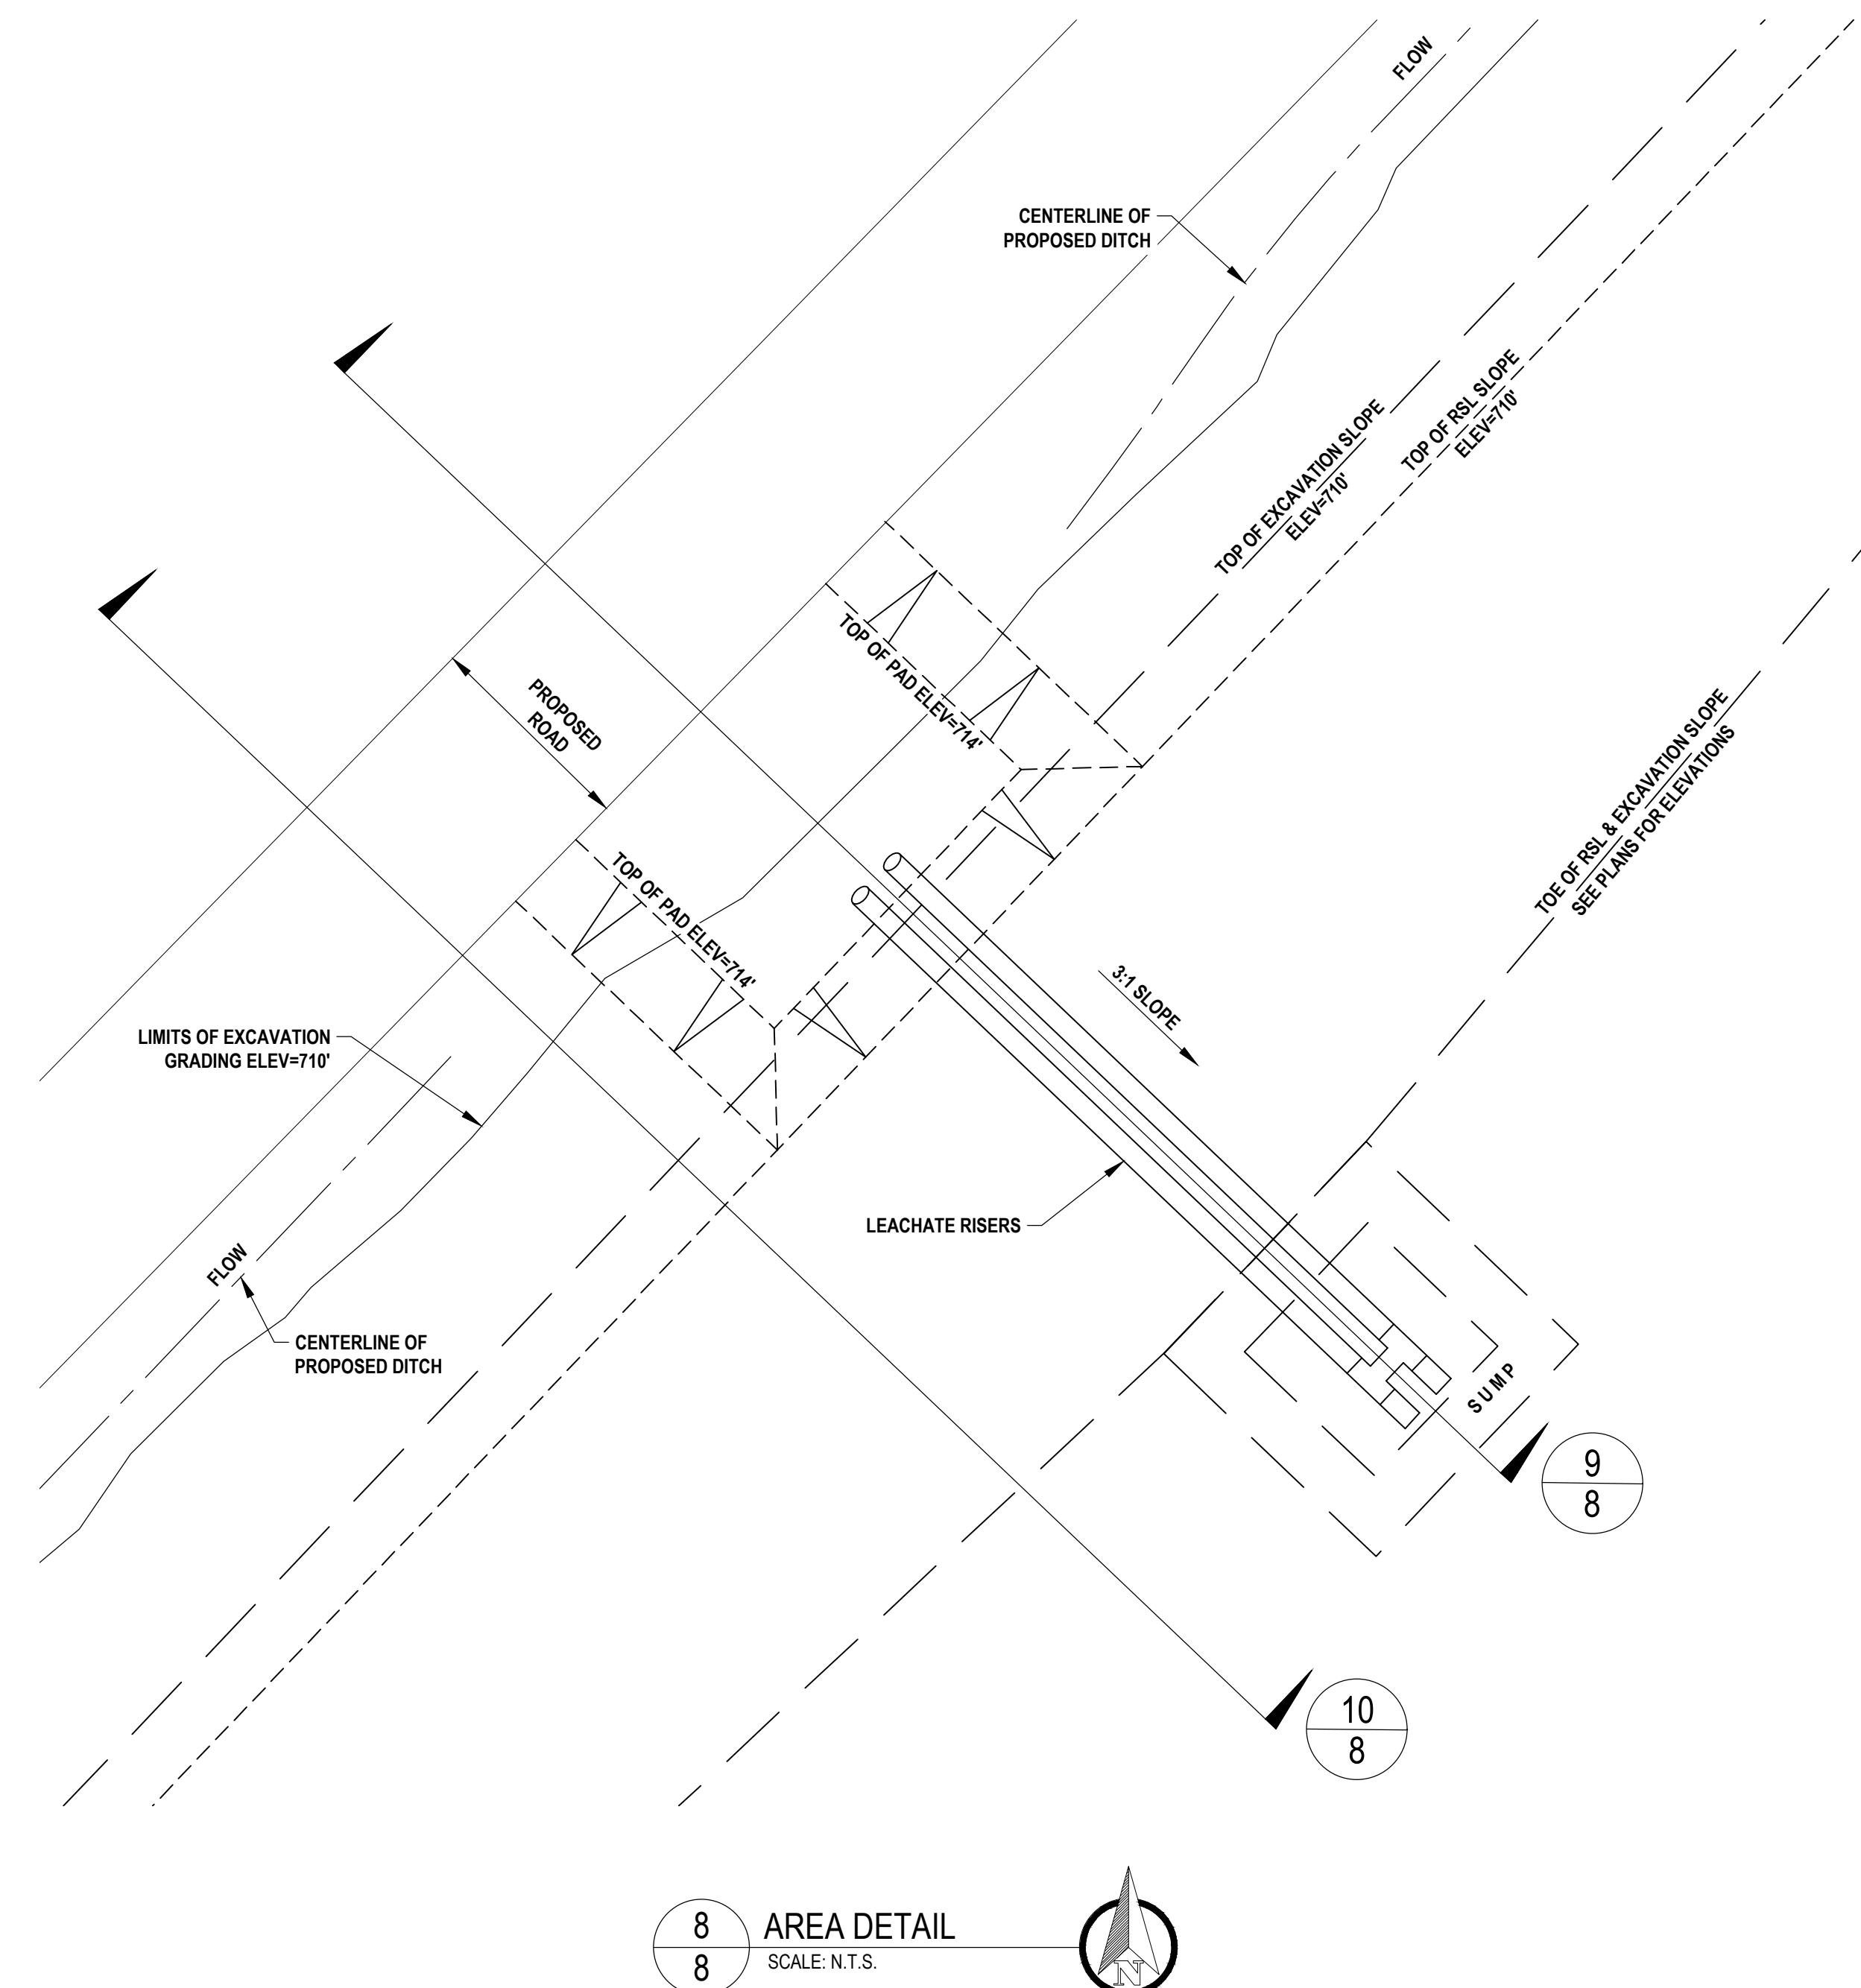


8
8

AREA DETAIL
SCALE: N.T.S.

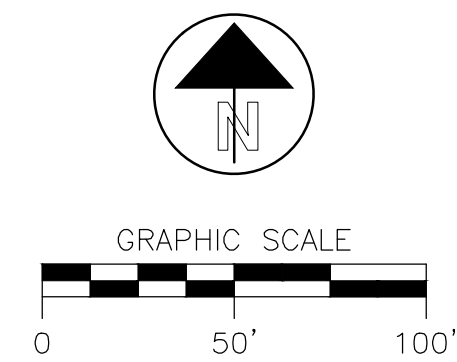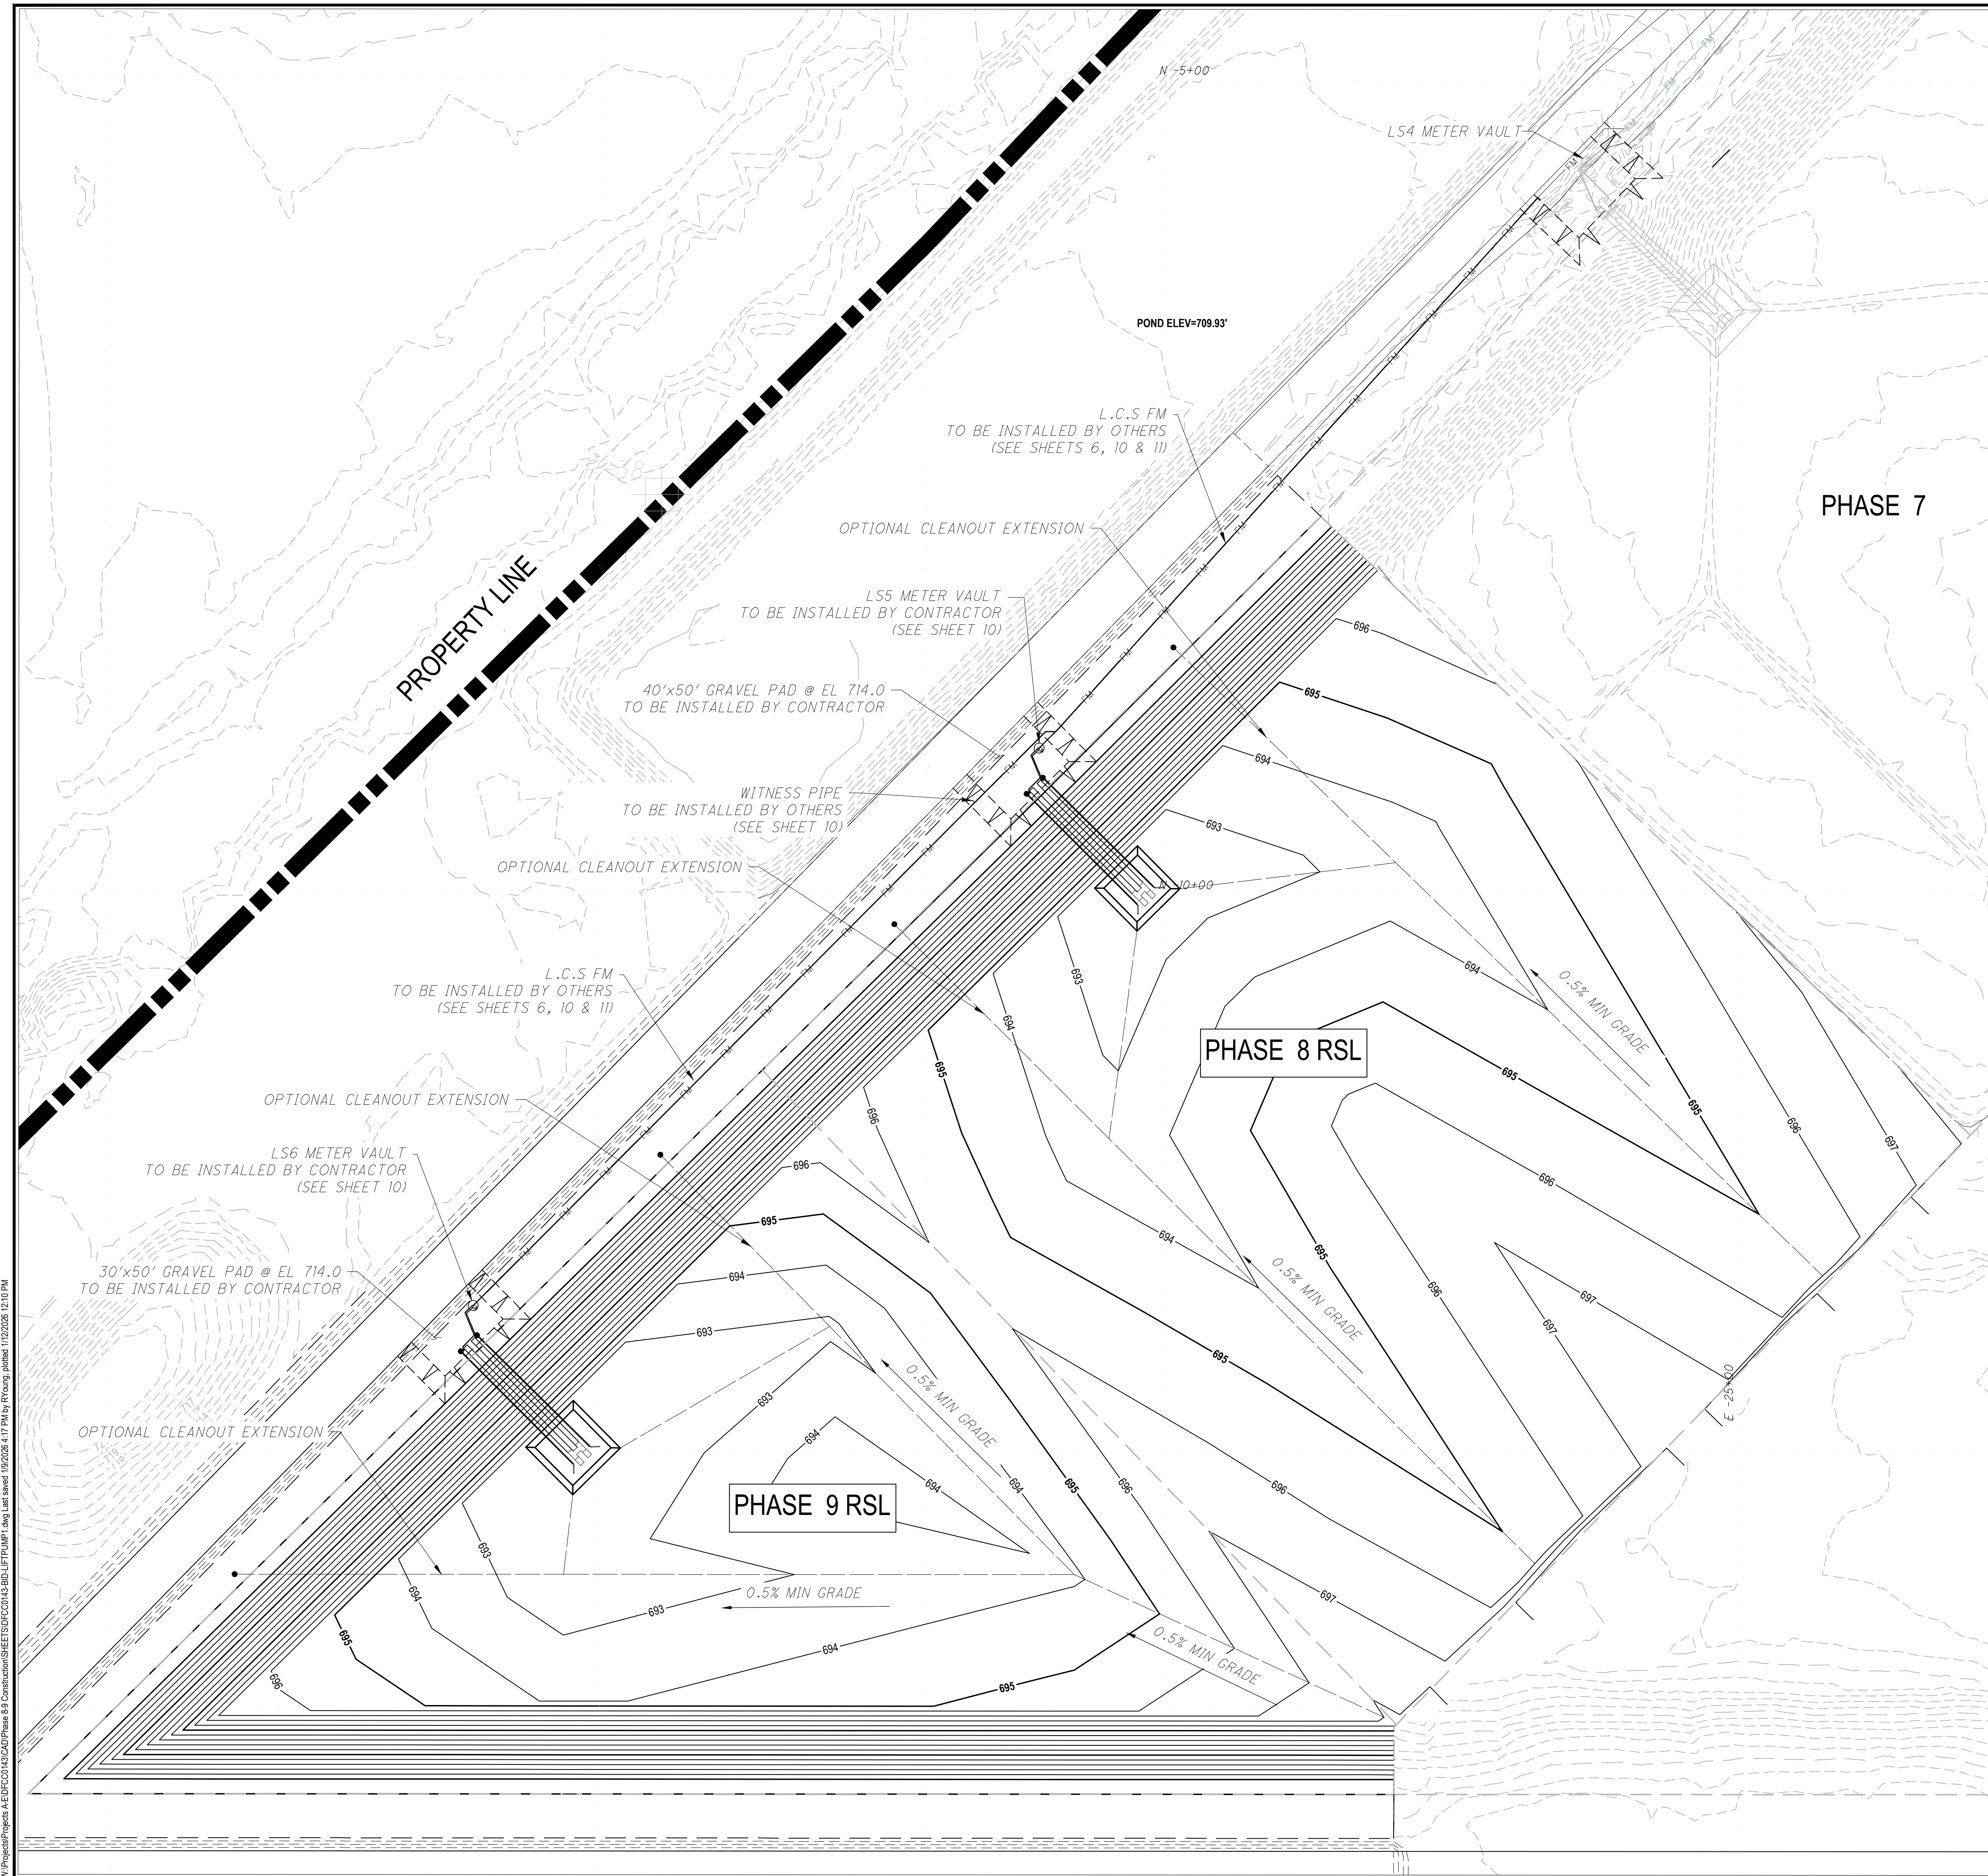


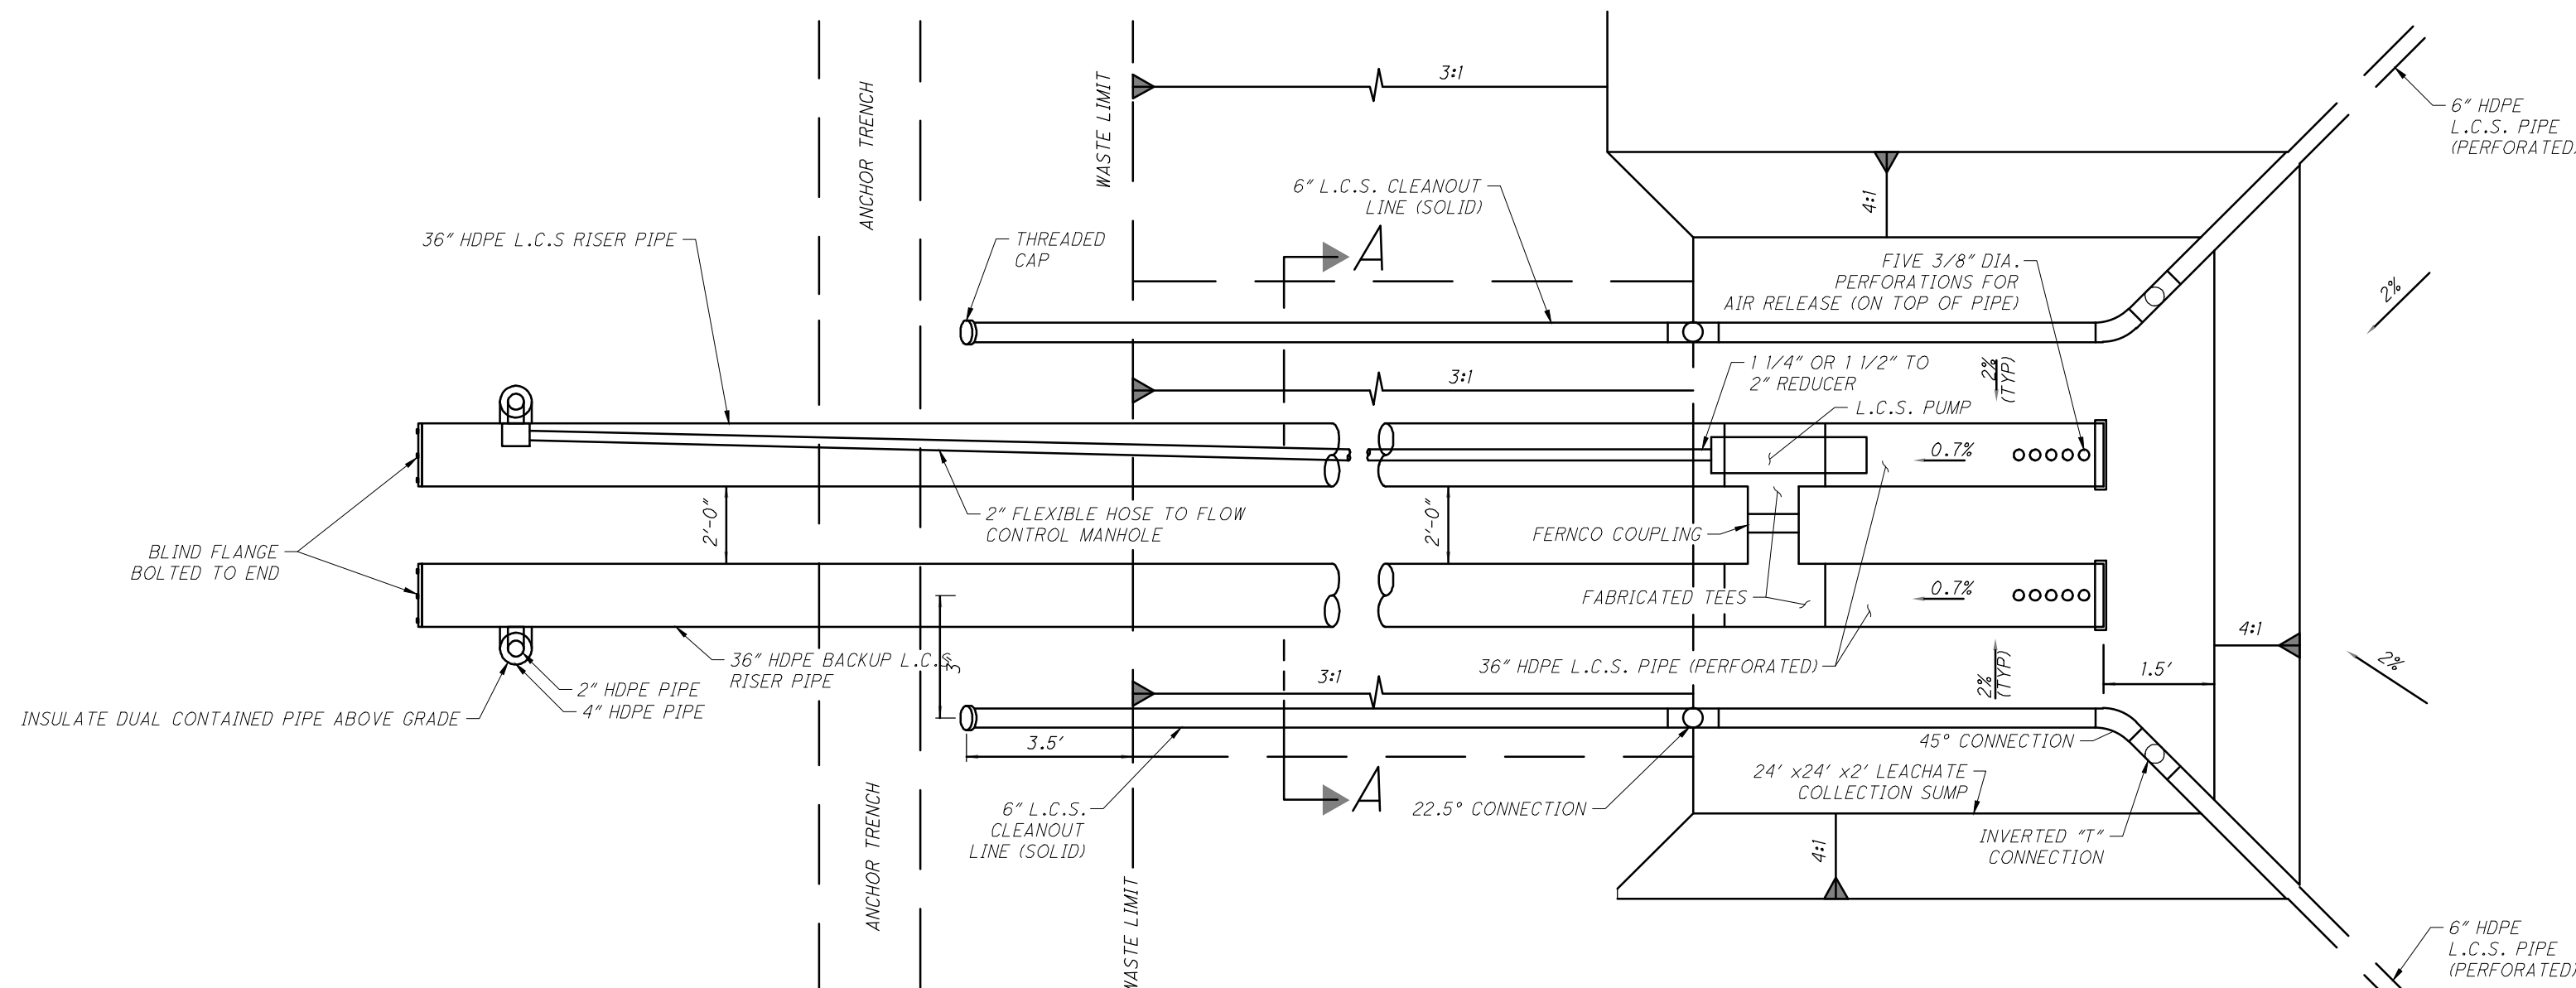


1
10 PRIMARY L.C.S. SUMP PLAN VIEW
SCALE: N.T.S. BY CONTRACTOR
*SEE SPEC FOR PUMP MODEL INFORMATION L55/6 HAVE DIFFERENT PUMP SELECTIONS

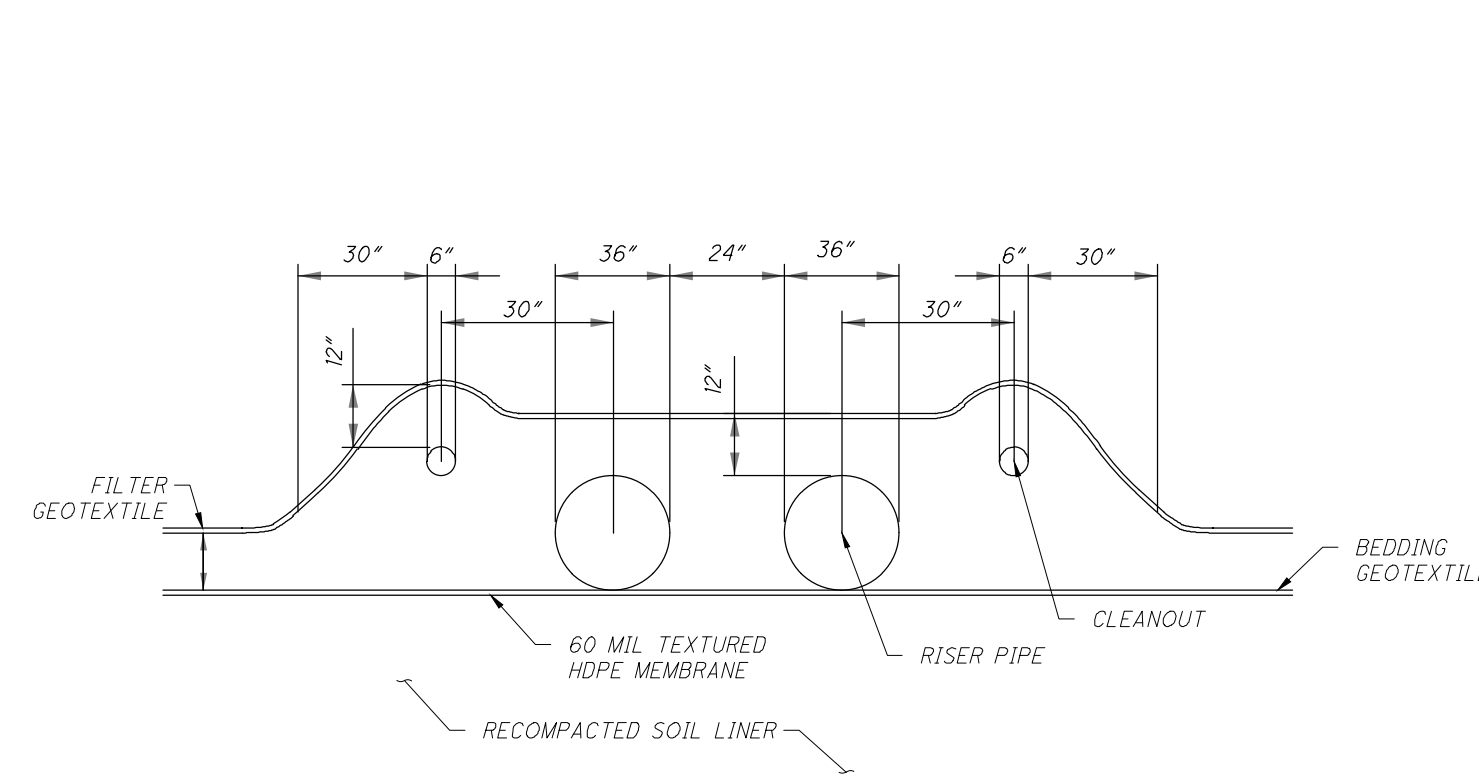


A-A
10 SECTION OF L.C.S. RISER PIPE AND CLEANOUTS
SCALE: N.T.S.

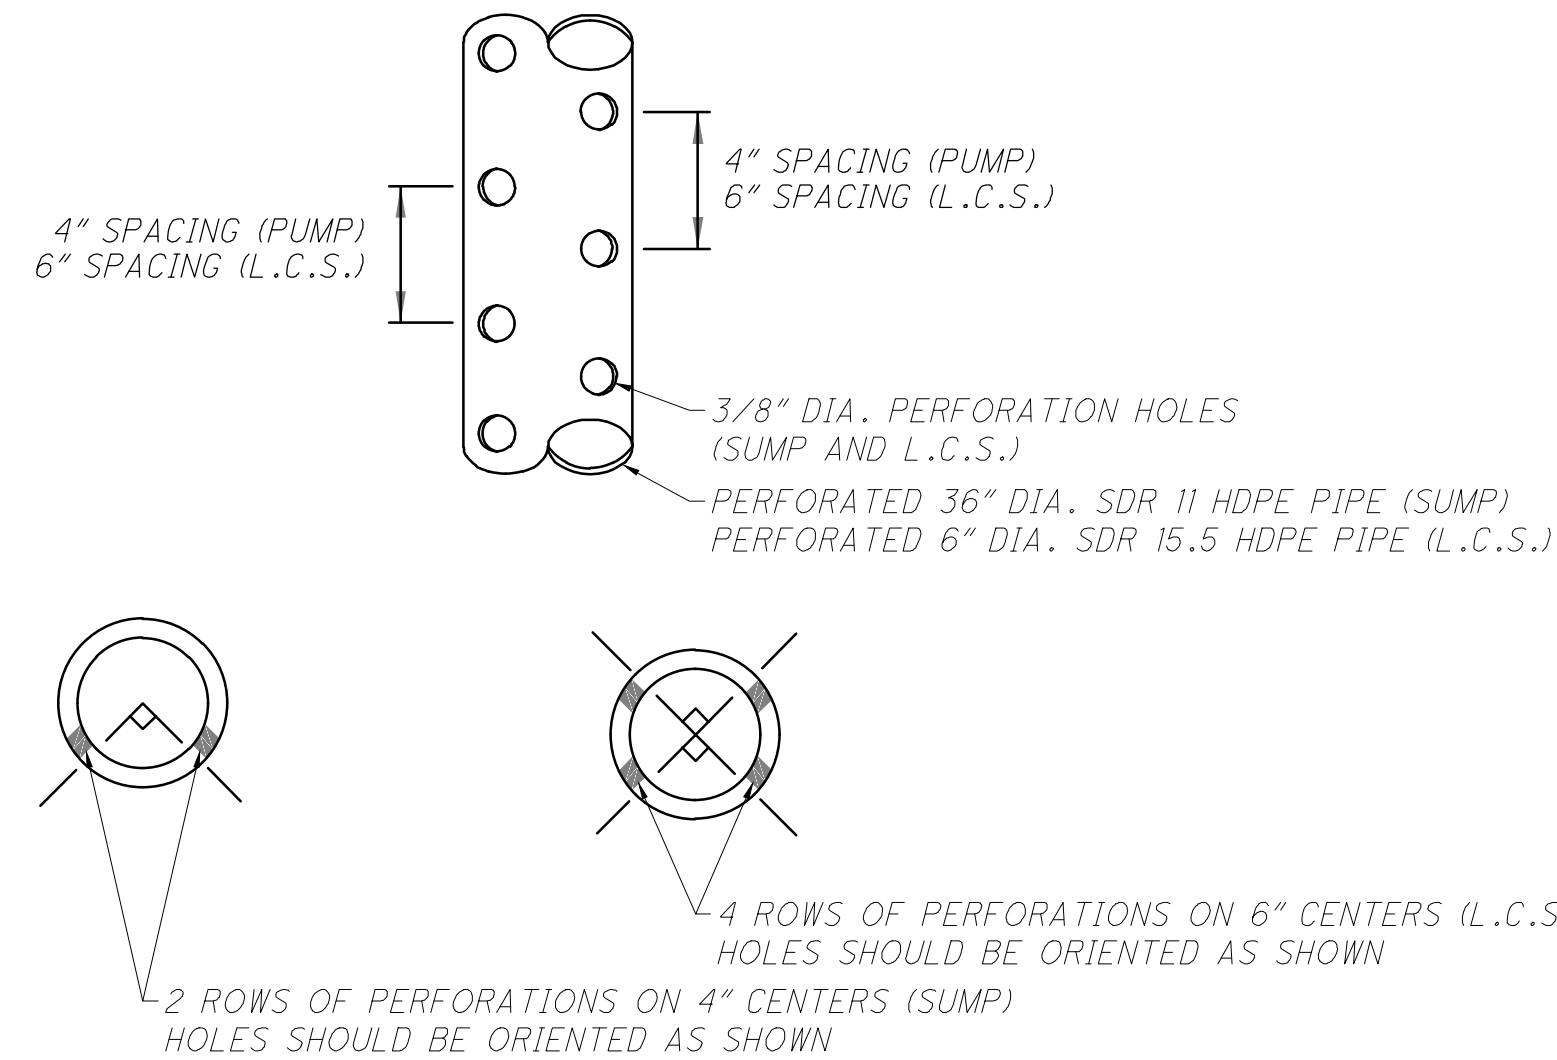

4
10 L.C.S. PERFORATED PIPE
SCALE: N.T.S.

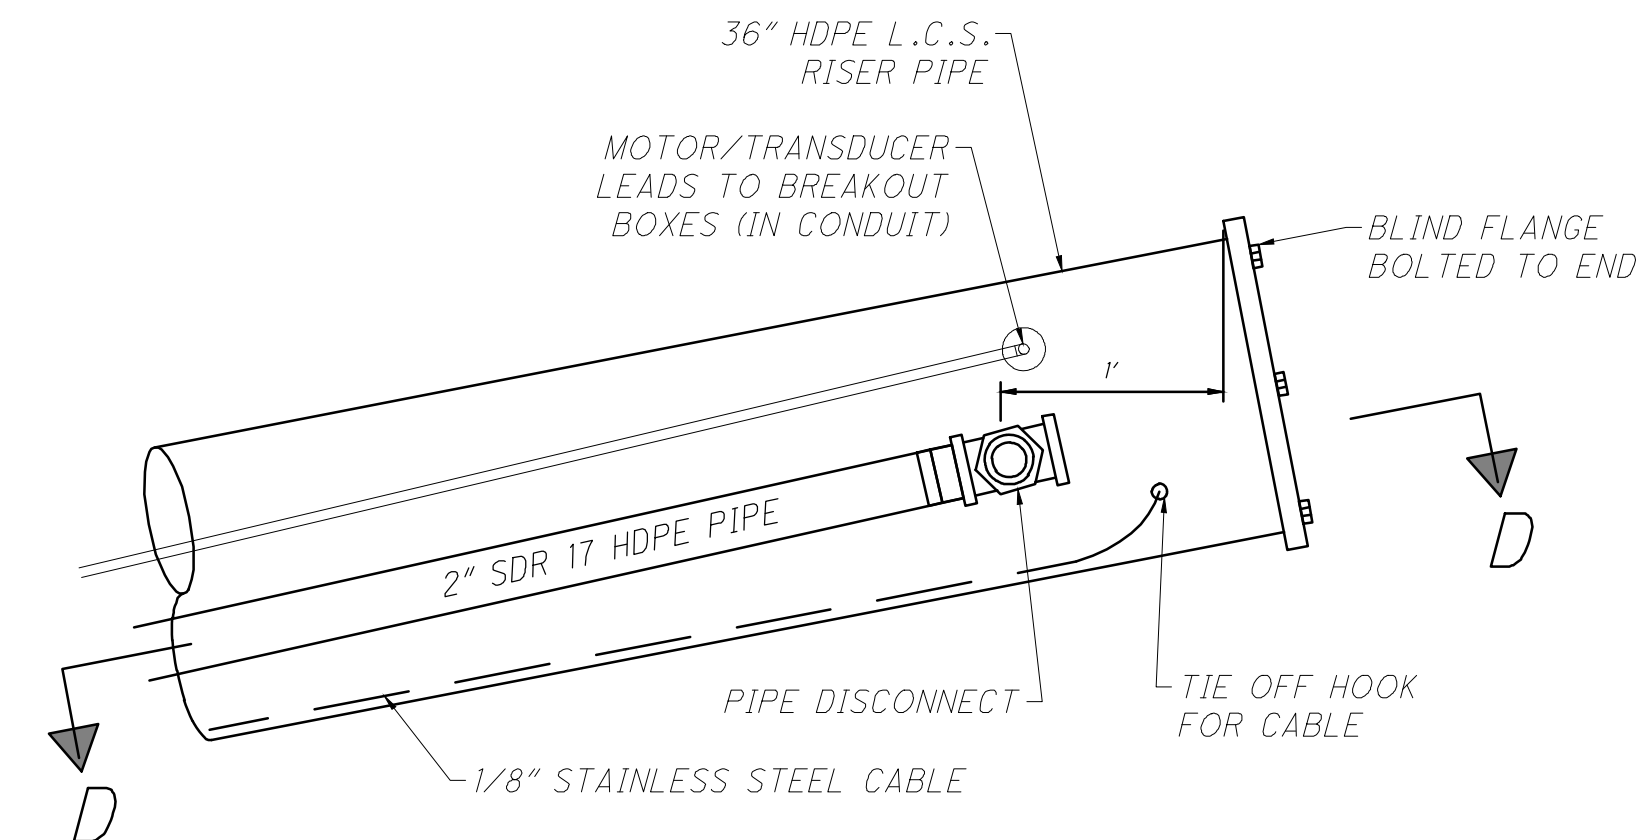


5
10 L.C.S. RISER PIPE END
SCALE: N.T.S.

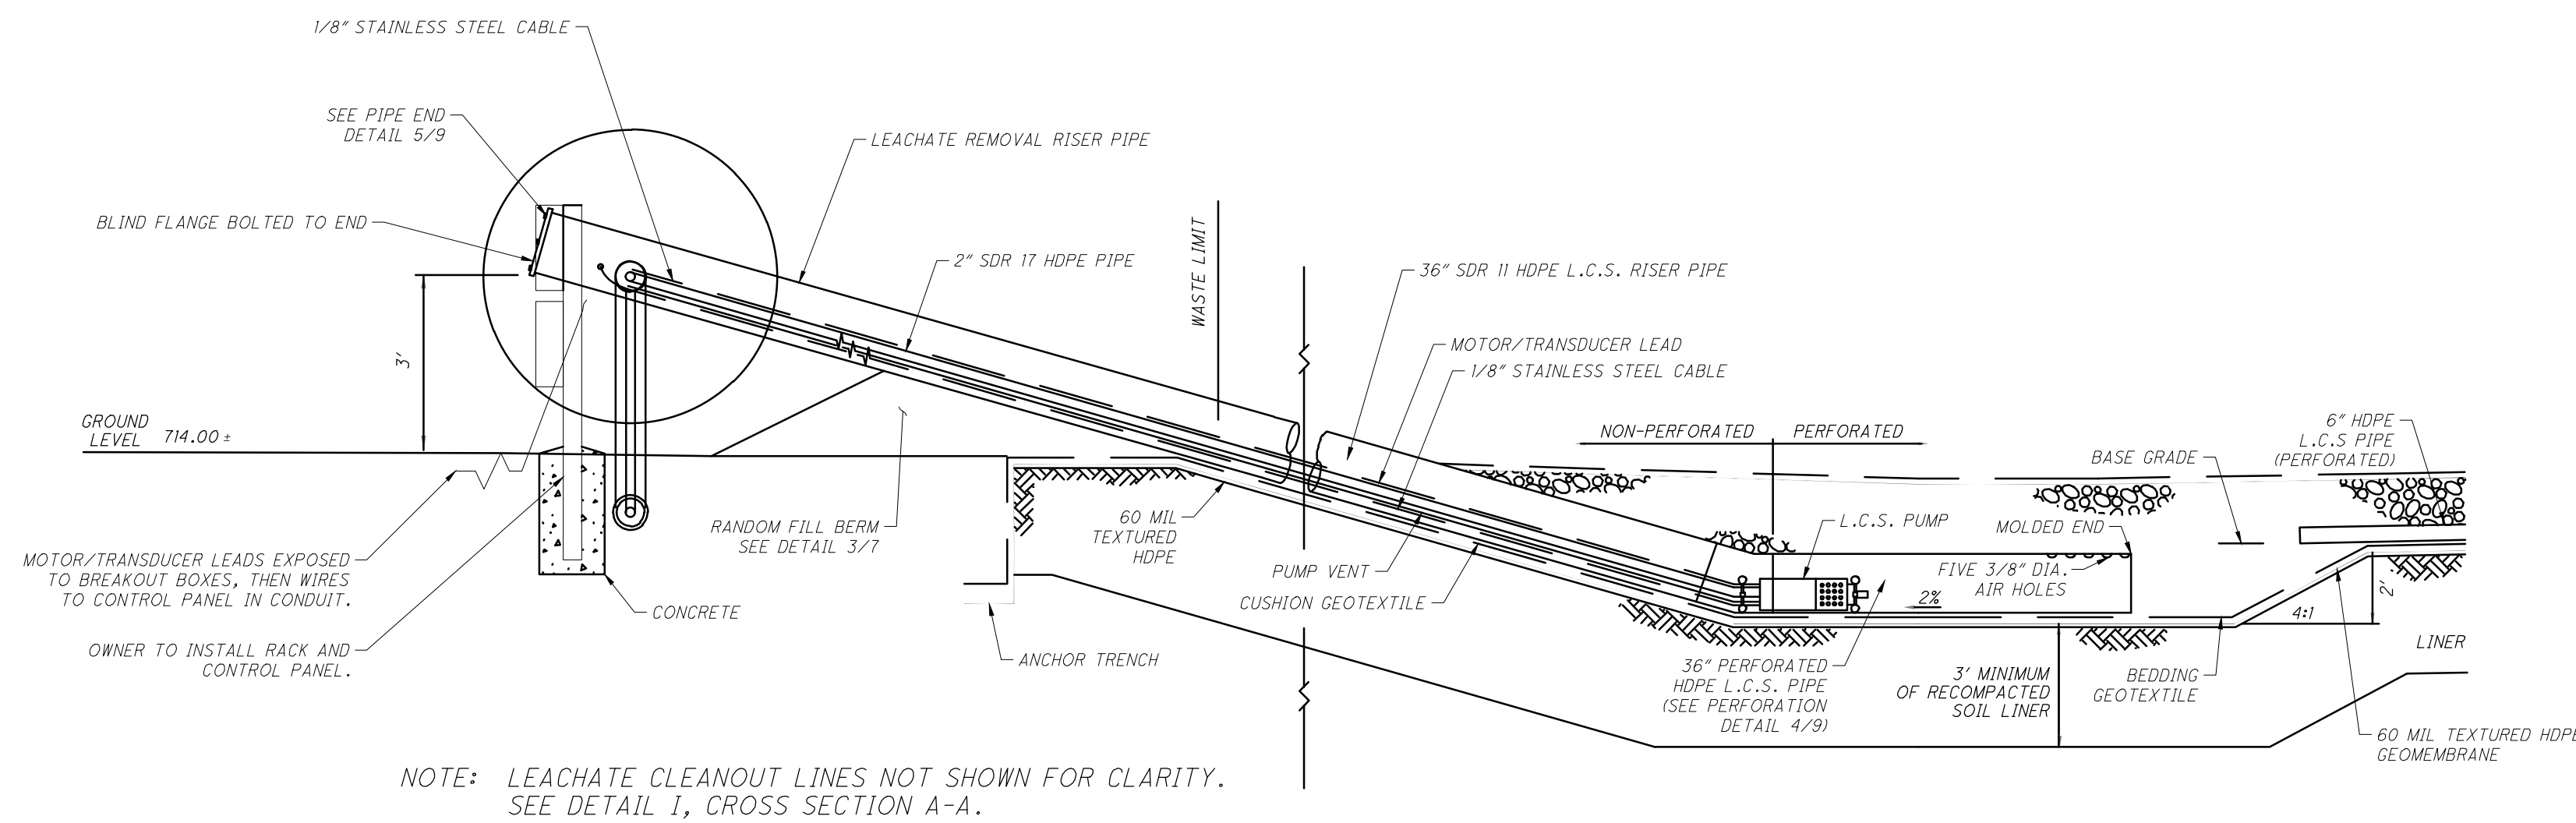


3
10 LEACHATE REMOVAL RISER PIPE END
SCALE: N.T.S. BY CONTRACTOR

2
10 L.C.S. PUMP PROFILE
SCALE: N.T.S.
*SEE SPEC FOR PUMP MODEL INFORMATION L55/6 HAVE DIFFERENT PUMP SELECTIONS

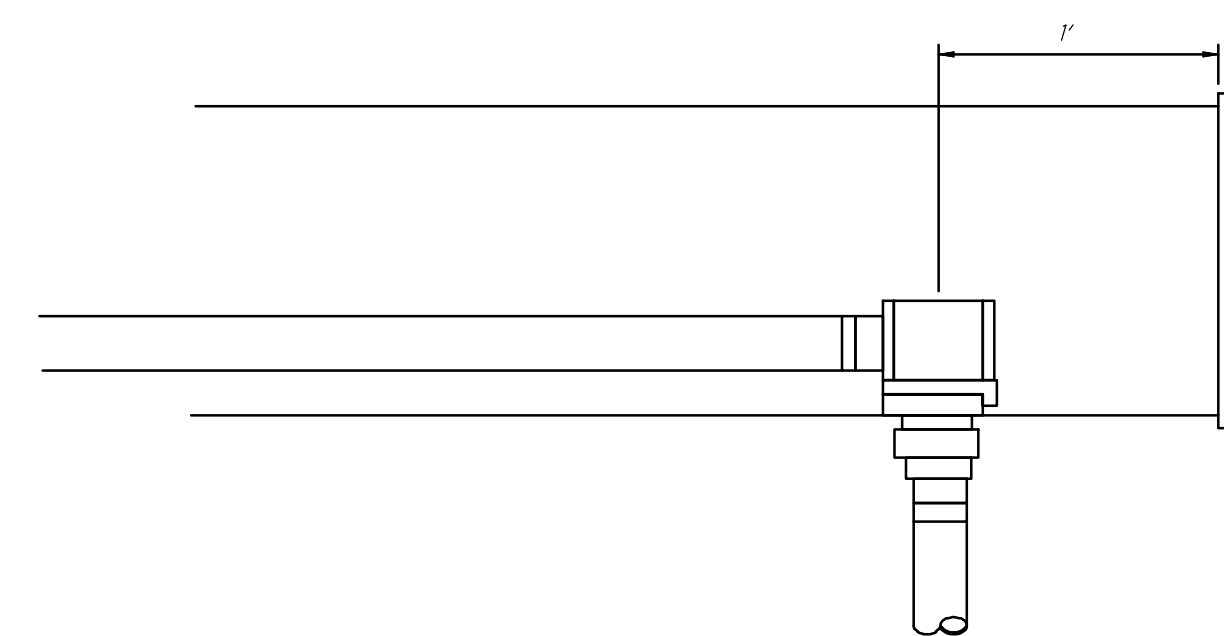


D-D
10 SECTION OF L.C.S. RISER PIPE END
SCALE: N.T.S. BY OWNER

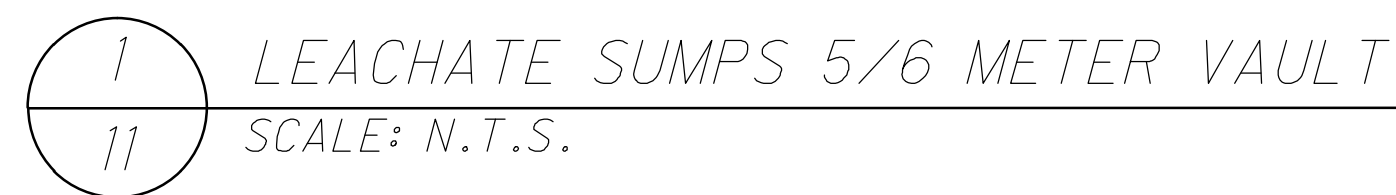

DETAILS - LEACHATE COLLECTION AND REMOVAL SYSTEMS 2

DEFIANCE COUNTY
LANDFILL
13207 CANAL ROAD
DEFIANCE, OHIO 43512

PREPARED FOR
DEFIANCE COUNTY
BOARD OF
COMMISSIONERS
500 COURT STREET
DEFIANCE, OHIO 43512

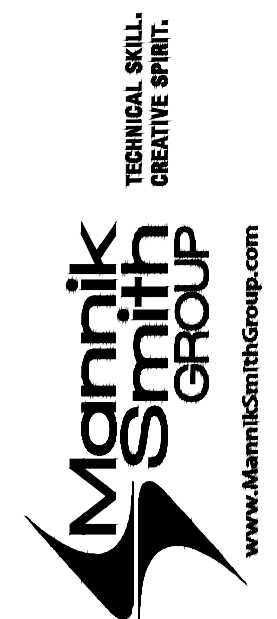

1800 INDIAN WOOD CIRCLE

MAUMEE, OH 43537
TEL: 419.891.2222

PROJECT DATE: NOVEMBER 2025

PROJECT NO: DFCC0143
DRAWN BY: AGP

HECKED BY: PM

[illegible]

POINT	NORTHING	EASTING	SUBGRADE ELEVATION
1109	-1,147.40	-2,358.99	695.41
1111	-1,168.61	-2,358.47	695.43
1112	-1,157.59	-2,370.04	694.59
1113	-1,083.96	-2,425.64	694.73
1114	-1,092.12	-2,438.81	694.03
1115	-1,025.44	-2,487.11	694.10
1116	-1,040.35	-2,493.20	693.60
1117	-966.92	-2,548.59	693.50
1118	-975.73	-2,561.08	693.03
1119	-908.40	-2,610.07	692.88
1120	-917.21	-2,622.55	692.54
1121	-856.59	-2,664.48	693.12
1122	-870.86	-2,671.25	692.76
1123	-801.37	-2,722.49	693.73
1124	-812.58	-2,732.47	693.41
1125	-779.56	-2,769.54	709.95
1155	-1,507.58	-2,712.58	695.13
1156	-1,494.13	-2,725.65	695.00
1157	-1,442.40	-2,775.91	694.50
1158	-1,390.67	-2,826.16	694.00
1159	-1,328.81	-2,886.08	693.47
1160	-1,266.45	-2,946.85	693.00
1161	-1,237.22	-2,974.83	692.77
1162	-1,213.55	-2,997.95	693.00
1163	-1,178.24	-3,032.12	693.34
1164	-1,142.93	-3,066.29	693.71
1165	-1,114.36	-3,094.01	707.00
1166	-1,508.42	-2,691.89	695.07
1167	-1,500.00	-2,701.89	695.08
1168	-1,472.34	-2,655.05	694.85
1169	-1,462.28	-2,665.13	694.85
1170	-1,457.39	-2,670.03	693.60
1171	-1,107.84	-3,100.33	710.00
1172	-1,396.98	-2,730.59	693.04
1173	-1,346.04	-2,781.65	692.68
1174	-1,285.23	-2,842.60	692.27
1175	-1,223.74	-2,904.25	691.79
1176	-1,195.18	-2,932.87	691.56
1177	-1,146.15	-2,978.06	692.00
1178	-1,105.03	-3,023.24	692.62
1179	-1,074.62	-3,053.73	707.00
1180	-1,068.21	-3,060.16	710.00
1181	-1,426.97	-2,609.68	695.30
1182	-1,416.40	-2,620.27	695.30
1183	-1,408.29	-2,628.40	692.11
1184	-1,351.55	-2,685.28	691.75
1185	-1,300.62	-2,736.33	691.43
1186	-1,239.81	-2,797.29	690.99
1187	-1,178.32	-2,858.93	690.48
1188	-1,149.76	-2,887.56	690.25
1189	-1,126.38	-2,910.99	690.56
1190	-1,091.68	-2,945.77	691.02

1191	-1,062.55	-2,974.98	691.41
1192	-1,029.56	-3,008.05	707.00
1193	-1,023.14	-3,014.48	710.00
1194	-1,382.82	-2,566.67	695.58
1195	-1,372.22	-2,577.29	695.57
1196	-1,368.14	-2,581.38	693.43
1197	-1,307.92	-2,641.75	693.05
1198	-1,256.99	-2,692.80	692.73
1199	-1,196.18	-2,753.76	692.33
1200	-1,134.68	-2,815.41	691.61
1201	-1,082.75	-2,867.47	690.07
1202	-1,048.05	-2,902.25	689.89
1203	-1,021.74	-2,928.62	690.24
1204	-986.28	-2,964.17	707.00
1205	-979.86	-2,970.61	710.00
1206	-1,337.47	-2,522.48	694.78
1207	-1,327.04	-2,533.27	694.78
1208	-1,264.29	-2,598.22	694.35
1209	-1,214.17	-2,650.09	694.01
1210	-1,155.33	-2,713.02	693.56
1211	-1,152.92	-2,710.61	693.56
1212	-1,098.28	-2,779.09	692.04
1213	-1,087.65	-2,768.49	692.04
1214	-1,052.08	-2,836.87	690.43
1215	-1,029.82	-2,814.66	690.43
1216	-1,025.15	-2,870.55	689.50
1217	-996.33	-2,841.39	689.50
1218	-995.99	-2,899.37	689.50
1219	-967.18	-2,870.19	689.50
1220	-1,013.84	-2,870.48	687.50
1221	-996.26	-2,852.70	687.50
1222	-978.49	-2,870.26	687.50
1223	-996.06	-2,888.05	687.50
1224	-948.10	-2,925.46	707.00
1225	-941.78	-2,932.01	710.00
1226	-1,292.57	-2,478.83	695.63
1227	-1,282.09	-2,489.66	695.59
1228	-1,279.66	-2,492.18	693.53
1229	-1,219.92	-2,553.97	693.13
1230	-1,169.79	-2,605.82	692.76
1231	-1,109.93	-2,667.73	692.29
1232	-1,049.40	-2,730.33	691.57
1233	-998.28	-2,783.20	690.04
1234	-964.13	-2,818.53	689.90
1235	-938.71	-2,844.82	690.23
1236	-903.78	-2,880.94	707.00
1237	-897.38	-2,887.56	710.00
1238	-1,247.71	-2,435.08	694.80
1239	-1,237.12	-2,446.03	694.71
1240	-1,232.24	-2,451.08	692.29
1241	-1,175.56	-2,509.71	691.84
1242	-1,125.42	-2,561.56	691.44
1243	-1,065.57	-2,623.47	690.96
1244	-1,005.04	-2,686.07	690.48

1245	-953.92	-2,738.94	690.62
1246	-919.76	-2,774.27	691.06
1247	-891.88	-2,803.11	691.43
1248	-859.45	-2,836.65	707.00
1249	-853.07	-2,843.25	710.00
1250	-1,203.11	-2,391.78	694.81
1251	-1,192.50	-2,402.75	694.45
1252	-1,190.05	-2,405.28	693.62
1253	-1,131.54	-2,465.80	693.14
1254	-1,081.41	-2,517.65	692.72
1255	-1,021.55	-2,579.56	692.24
1256	-961.02	-2,642.16	691.76
1257	-909.90	-2,695.04	691.82
1258	-875.75	-2,730.36	692.22
1259	-845.42	-2,761.73	692.61
1260	-815.47	-2,792.71	707.00
1261	-809.11	-2,799.29	710.00
1266	-919.60	-2,599.15	693.00
1267	-870.81	-2,649.55	693.00
1269	-773.98	-2,751.26	707.00
1270	-767.70	-2,757.87	710.00
1271	-1,148.21	-2,926.35	691.00
1272	-1,108.22	-2,881.89	690.00
1273	-1,098.50	-2,891.50	690.00
1274	-892.39	-2,626.88	692.77
1275	-919.55	-2,653.13	692.00
1276	-980.20	-2,711.76	690.28
1277	-985.99	-2,758.29	690.00
1278	-942.99	-2,713.99	691.00
1279	-975.53	-2,768.63	690.00
1280	-839.62	-2,720.19	693.00
1281	-1,115.54	-2,724.10	693.00
1282	-1,141.86	-2,751.17	693.00
1283	-1,014.34	-2,827.01	690.00
1284	-1,039.56	-2,852.53	690.00
1285	-1,483.73	-2,764.49	694.00
1286	-1,441.51	-2,856.35	692.00
1287	-1,404.35	-2,936.20	691.00
1288	-1,376.31	-2,995.10	691.30
1289	-1,346.31	-3,084.76	691.00
1290	-1,343.06	-3,136.06	690.00
1291	-1,339.80	-3,187.35	689.00
1292	-1,504.20	-2,795.60	694.00
1293	-1,475.97	-2,908.73	692.00
1294	-1,501.20	-2,869.06	693.00
1295	-1,498.20	-2,995.08	692.00
1296	-1,424.63	-2,908.72	691.00
1297	-1,349.14	-2,983.40	690.50
1298	-1,293.93	-3,030.60	690.00
1299	-1,265.20	-3,058.94	689.80
1300	-1,196.07	-3,062.91	692.00
1301	-1,251.26	-3,016.83	691.30
1302	-1,368.63	-3,216.50	689.00
1303	-1,339.48	-3,245.33	689.00

1304	-1,310.64	-3,216.17	689.00
1305	-1,339.74	-3,198.66	687.00
1306	-1,357.32	-3,216.44	687.00
1307	-1,339.54	-3,234.02	687.00
1308	-1,321.96	-3,216.23	687.00
1309	-1,295.21	-3,130.35	689.40
1310	-1,325.22	-3,201.76	689.00
1311	-1,417.44	-3,222.22	689.26
1312	-1,494.57	-3,222.23	690.79
1313	-1,417.44	-3,080.75	690.00
1314	-1,450.59	-3,303.02	691.00
1315	-1,488.70	-3,395.91	693.00
1316	-1,503.56	-3,432.13	693.78
1317	-1,498.21	-3,307.17	692.00
1318	-1,495.20	-3,182.81	691.00
1319	-1,185.16	-3,103.99	692.51
1320	-1,154.00	-3,134.17	707.00
1321	-1,147.48	-3,140.50	710.00
1322	-1,227.34	-3,141.69	691.33
1323	-1,193.64	-3,174.34	707.00
1324	-1,187.12	-3,180.67	710.00
1325	-1,269.52	-3,179.40	690.15
1326	-1,233.28	-3,214.51	707.00
1327	-1,226.75	-3,220.84	710.00
1328	-1,272.92	-3,254.67	707.00
1329	-1,266.39	-3,261.01	710.00
1330	-1,350.60	-3,257.99	689.32
1331	-1,312.58	-3,294.83	707.00
1332	-1,306.02	-3,301.18	710.00
1333	-1,387.89	-3,300.44	690.41
1334	-1,352.20	-3,335.01	707.00
1335	-1,345.66	-3,341.35	710.00
1336	-1,425.17	-3,342.88	691.50
1337	-1,391.82	-3,375.19	707.00
1338	-1,385.29	-3,381.52	710.00
1339	-1,462.46	-3,385.33	692.58
1340	-1,431.44	-3,415.38	707.00
1341	-1,424.93	-3,421.69	710.00
1342	-1,471.06	-3,455.56	707.00
1343	-1,464.57	-3,461.86	710.00
1344	-1,510.70	-3,495.74	707.00
1345	-1,504.20	-3,502.03	710.00
1346	-1,543.16	-3,528.63	707.00
1347	-1,552.21	-3,550.71	710.00
1348	-1,519.20	-3,470.23	699.00
1349	-1,543.16	-3,502.23	707.00
1350	-1,552.21	-3,502.23	710.00
1351	-1,543.18	-3,446.23	707.00
1352	-1,552.21	-3,446.23	710.00
1353	-1,501.77	-3,390.23	693.18
1354	-1,543.18	-3,390.23	707.00
1355	-1,552.21	-3,390.23	710.00
1356	-1,499.37	-3,334.23	692.39
1357	-1,543.17	-3,334.23	707.00

1358	-1,552.21	-3,334.23	710.00
1359	-1,496.97	-3,278.23	691.59
1360	-1,543.17	-3,278.23	707.00
1361	-1,552.21	-3,278.23	710.00
1362	-1,543.16	-3,222.23	707.00
1363	-1,552.21	-3,222.23	707.00
1364	-1,495.47	-3,166.23	691.09
1365	-1,543.16	-3,166.23	707.00
1366	-1,552.21	-3,166.23	710.00
1367	-1,496.36	-3,110.23	691.39
1368	-1,543.17	-3,110.23	707.00
1369	-1,552.21	-3,110.23	710.00
1370	-1,497.26	-3,054.23	691.68
1371	-1,543.18	-3,054.23	707.00
1372	-1,552.21	-3,054.23	710.00
1373	-1,543.19	-2,998.23	707.00
1374	-1,552.21	-2,998.23	710.00
1375	-1,499.46	-2,942.23	692.42
1376	-1,543.19	-2,942.23	707.00
1377	-1,552.21	-2,942.23	710.00
1378	-1,500.79	-2,886.23	692.86
1379	-1,543.19	-2,886.23	707.00
1380	-1,552.21	-2,886.23	710.00
1381	-1,502.78	-2,830.23	693.53
1382	-1,543.18	-2,830.23	707.00
1383	-1,552.21	-2,830.23	710.00
1384	-1,505.07	-2,774.23	694.29
1385	-1,543.17	-2,774.23	707.00
1386	-1,552.21	-2,774.23	710.00
1387	-1,543.16	-2,712.61	707.00
1388	-1,552.21	-2,712.61	710.00
1389	-1,420.40	-2,902.29	691.00
1390	-1,348.26	-3,053.99	691.60
1391	-1,126.01	-2,744.39	693.00
1392	-1,122.41	-2,740.75	693.00

POINT	NORTHING	EASTING	TOP OF RSL ELEVATION
2109	-1,147.40	-2,358.99	698.57
2111	-1,168.61	-2,358.47	698.60
2112	-1,157.59	-2,370.04	697.69
2113	-1,083.96	-2,425.64	697.91
2114	-1,092.12	-2,438.81	697.21
2115	-1,025.44	-2,487.11	697.31
2116	-1,040.35	-2,493.20	696.73
2117	-966.92	-2,548.59	696.65
2118	-975.73	-2,561.08	696.17
2119	-908.40	-2,610.07	696.02
2120	-917.21	-2,622.55	695.71
2121	-856.59	-2,664.48	696.24
2122	-870.86	-2,671.25	695.94
2123	-801.37	-2,722.49	696.84
2124	-812.58	-2,732.47	696.52
2125	-779.56	-2,769.54	710.11
2155	-1,507.58	-2,712.58	698.13
2156	-1,494.13	-2,725.65	698.00
2157	-1,442.40	-2,775.91	697.50
2158	-1,390.67	-2,826.16	697.00
2159	-1,328.81	-2,886.08	696.47
2160	-1,266.45	-2,946.85	696.00
2161	-1,237.22	-2,974.83	695.77
2162	-1,213.55	-2,997.95	696.00
2163	-1,178.24	-3,032.12	696.34
2164	-1,142.93	-3,066.29	696.71
2165	-1,114.36	-3,094.01	710.00
2166	-1,508.42	-2,691.89	698.07
2167	-1,500.00	-2,701.89	698.08
2168	-1,472.34	-2,655.05	697.85
2169	-1,462.28	-2,665.13	697.85
2170	-1,457.39	-2,670.03	696.60
2171	-1,107.84	-3,100.33	710.00
2172	-1,396.98	-2,730.59	696.04
2173	-1,346.04	-2,781.65	695.68
2174	-1,285.23	-2,842.60	695.27
2175	-1,223.74	-2,904.25	694.79
2176	-1,195.18	-2,932.87	694.56
2177	-1,146.15	-2,978.06	695.00
2178	-1,105.03	-3,023.24	695.62
2179	-1,074.62	-3,053.73	710.00
2180	-1,068.21	-3,060.16	710.00
2181	-1,426.97	-2,609.68	698.30
2182	-1,416.40	-2,620.27	698.30
2183	-1,408.29	-2,628.40	695.11
2184	-1,351.55	-2,685.28	694.75
2185	-1,300.62	-2,736.33	694.43
2186	-1,239.81	-2,797.29	693.99
2187	-1,178.32	-2,858.93	693.48
2188	-1,149.76	-2,887.56	693.25
2189	-1,126.38	-2,910.99	693.56
2190	-1,091.68	-2,945.77	694.02


2191	-1,062.55	-2,974.98	694.41
2192	-1,029.56	-3,008.05	710.00
2193	-1,023.14	-3,014.48	710.00
2194	-1,382.82	-2,566.67	698.58
2195	-1,372.22	-2,577.29	698.57
2196	-1,368.14	-2,581.38	696.43
2197	-1,307.92	-2,641.75	696.05
2198	-1,256.99	-2,692.80	695.73
2199	-1,196.18	-2,753.76	695.33
2200	-1,134.68	-2,815.41	694.61
2201	-1,082.75	-2,867.47	693.07
2202	-1,048.05	-2,902.25	692.89
2203	-1,021.74	-2,928.62	693.24
2204	-986.28	-2,964.17	710.00
2205	-979.86	-2,970.61	710.00
2206	-1,337.47	-2,522.48	697.78
2207	-1,327.04	-2,533.27	697.78
2208	-1,264.29	-2,598.22	697.35
2209	-1,214.17	-2,650.09	697.01
2210	-1,155.33	-2,713.02	696.56
2211	-1,152.92	-2,710.61	696.56
2212	-1,098.28	-2,779.09	695.04
2213	-1,087.65	-2,768.49	695.04
2214	-1,052.08	-2,836.87	693.43
2215	-1,029.82	-2,814.66	693.43
2216	-1,025.15	-2,870.55	692.50
2217	-996.33	-2,841.39	692.50
2218	-995.99	-2,899.37	692.50
2219	-967.18	-2,870.19	692.50
2220	-1,013.84	-2,870.48	690.50
2221	-996.26	-2,852.70	690.50
2222	-978.49	-2,870.26	690.50
2223	-996.06	-2,888.05	690.50
2224	-948.10	-2,925.46	710.00
2225	-941.78	-2,932.01	710.00
2226	-1,292.57	-2,478.83	698.63
2227	-1,282.09	-2,489.66	698.59
2228	-1,279.66	-2,492.18	696.53
2229	-1,219.92	-2,553.97	696.13
2230	-1,169.79	-2,605.82	695.76
2231	-1,109.93	-2,667.73	695.29
2232	-1,049.40	-2,730.33	694.57
2233	-998.28	-2,783.20	693.04
2234	-964.13	-2,818.53	692.90
2235	-938.71	-2,844.82	693.23
2236	-903.78	-2,880.94	710.00
2237	-897.38	-2,887.56	710.00
2238	-1,247.71	-2,435.08	697.80
2239	-1,237.12	-2,446.03	697.71
2240	-1,232.24	-2,451.08	695.29
2241	-1,175.56	-2,509.71	694.84
2242	-1,125.42	-2,561.56	694.44
2243	-1,065.57	-2,623.47	693.96
2244	-1,005.04	-2,686.07	693.48

2245	-953.92	-2,738.94	693.62
2246	-919.76	-2,774.27	694.06
2247	-891.88	-2,803.11	694.43
2248	-859.45	-2,836.65	710.00
2249	-853.07	-2,843.25	710.00
2250	-1,203.11	-2,391.78	697.81
2251	-1,192.50	-2,402.75	697.45
2252	-1,190.05	-2,405.28	696.62
2253	-1,131.54	-2,465.80	696.14
2254	-1,081.41	-2,517.65	695.72
2255	-1,021.55	-2,579.56	695.24
2256	-961.02	-2,642.16	694.76
2257	-909.90	-2,695.04	694.82
2258	-875.75	-2,730.36	695.22
2259	-845.42	-2,761.73	695.61
2260	-815.47	-2,792.71	710.00
2261	-809.11	-2,799.29	710.00
2266	-919.60	-2,599.15	696.00
2267	-870.81	-2,649.55	696.00
2269	-773.98	-2,751.26	710.00
2270	-767.70	-2,757.87	710.00
2271	-1,148.21	-2,926.35	694.00
2272	-1,108.22	-2,881.89	693.00
2273	-1,098.50	-2,891.50	693.00
2274	-892.39	-2,626.88	695.77
2275	-919.55	-2,653.13	695.00
2276	-980.20	-2,711.76	693.28
2277	-985.99	-2,758.29	693.00
2278	-942.99	-2,713.99	694.00
2279	-975.53	-2,768.63	693.00
2280	-839.62	-2,720.19	696.00
2281	-1,115.54	-2,724.10	696.00
2282	-1,141.86	-2,751.17	696.00
2283	-1,014.34	-2,827.01	693.00
2284	-1,039.56	-2,852.53	693.00
2285	-1,483.73	-2,764.49	697.00
2286	-1,441.51	-2,856.35	695.00
2287	-1,404.35	-2,936.20	694.00
2288	-1,376.31	-2,995.10	694.30
2289	-1,346.31	-3,084.76	694.00
2290	-1,343.06	-3,136.06	693.00
2291	-1,339.80	-3,187.35	692.00
2292	-1,504.20	-2,795.60	697.00
2293	-1,475.97	-2,908.73	695.00
2294	-1,501.20	-2,869.06	696.00
2295	-1,498.20	-2,995.08	695.00
2296	-1,424.63	-2,908.72	694.00
2297	-1,349.14	-2,983.40	693.50
2298	-1,293.93	-3,030.60	693.00
2299	-1,265.20	-3,058.94	692.80
2300	-1,196.07	-3,062.91	695.00
2301	-1,251.26	-3,016.83	694.30
2302	-1,368.63	-3,216.50	692.00
2303	-1,339.48	-3,245.33	692.00


2304	-1,310.64	-3,216.17	692.00
2305	-1,339.74	-3,198.66	690.00
2306	-1,357.32	-3,216.44	690.00
2307	-1,339.54	-3,234.02	690.00
2308	-1,321.96	-3,216.23	690.00
2309	-1,295.21	-3,130.35	692.40
2310	-1,325.22	-3,201.76	692.00
2311	-1,417.44	-3,222.22	692.26
2312	-1,494.57	-3,222.23	693.79
2313	-1,417.44	-3,080.75	693.00
2314	-1,450.59	-3,303.02	694.00
2315	-1,488.70	-3,395.91	696.00
2316	-1,503.56	-3,432.13	696.78
2317	-1,498.21	-3,307.17	695.00
2318	-1,495.20	-3,182.81	694.00
2319	-1,185.16	-3,103.99	695.51
2320	-1,154.00	-3,134.17	710.00
2321	-1,147.48	-3,140.50	710.00
2322	-1,227.34	-3,141.69	694.33
2323	-1,193.64	-3,174.34	710.00
2324	-1,187.12	-3,180.67	710.00
2325	-1,269.52	-3,179.40	693.15
2326	-1,233.28	-3,214.51	710.00
2327	-1,226.75	-3,220.84	710.00
2328	-1,272.92	-3,254.67	710.00
2329	-1,266.39	-3,261.01	710.00
2330	-1,350.60	-3,257.99	692.32
2331	-1,312.58	-3,294.83	710.00
2332	-1,306.02	-3,301.18	710.00
2333	-1,387.89	-3,300.44	693.41
2334	-1,352.20	-3,335.01	710.00
2335	-1,345.66	-3,341.35	710.00
2336	-1,425.17	-3,342.88	694.50
2337	-1,391.82	-3,375.19	710.00
2338	-1,385.29	-3,381.52	710.00
2339	-1,462.46	-3,385.33	695.58
2340	-1,431.44	-3,415.38	710.00
2341	-1,424.93	-3,421.69	710.00
2342	-1,471.06	-3,455.56	710.00
2343	-1,464.57	-3,461.86	710.00
2344	-1,510.70	-3,495.74	710.00
2345	-1,504.20	-3,502.03	710.00
2346	-1,543.16	-3,528.63	710.00
2347	-1,552.21	-3,550.71	710.00
2348	-1,519.20	-3,470.23	702.00
2349	-1,543.16	-3,502.23	710.00
2350	-1,552.21	-3,502.23	710.00
2351	-1,543.18	-3,446.23	710.00
2352	-1,552.21	-3,446.23	710.00
2353	-1,501.77	-3,390.23	696.18
2354	-1,543.18	-3,390.23	710.00
2355	-1,552.21	-3,390.23	710.00
2356	-1,499.37	-3,334.23	695.39
2357	-1,543.17	-3,334.23	710.00

2358	-1,552.21	-3,334.23	710.00
2359	-1,496.97	-3,278.23	694.59
2360	-1,543.17	-3,278.23	710.00
2361	-1,552.21	-3,278.23	710.00
2362	-1,543.16	-3,222.23	710.00
2363	-1,552.21	-3,222.23	710.00
2364	-1,495.47	-3,166.23	694.09
2365	-1,543.16	-3,166.23	710.00
2366	-1,552.21	-3,166.23	710.00
2367	-1,496.36	-3,110.23	694.39
2368	-1,543.17	-3,110.23	710.00
2369	-1,552.21	-3,110.23	710.00
2370	-1,497.26	-3,054.23	694.68
2371	-1,543.18	-3,054.23	710.00
2372	-1,552.21	-3,054.23	710.00
2373	-1,543.19	-2,998.23	710.00
2374	-1,552.21	-2,998.23	710.00
2375	-1,499.46	-2,942.23	695.42
2376	-1,543.19	-2,942.23	710.00
2377	-1,552.21	-2,942.23	710.00
2378	-1,500.79	-2,886.23	695.86
2379	-1,543.19	-2,886.23	710.00
2380	-1,552.21	-2,886.23	710.00
2381	-1,502.78	-2,830.23	696.53
2382	-1,543.18	-2,830.23	710.00
2383	-1,552.21	-2,830.23	710.00
2384	-1,505.07	-2,774.23	697.29
2385	-1,543.17	-2,774.23	710.00
2386	-1,552.21	-2,774.23	710.00
2387	-1,543.16	-2,712.61	710.00
2388	-1,552.21	-2,712.61	710.00
2389	-1,420.40	-2,902.29	694.00
2390	-1,348.26	-3,053.99	694.60
2391	-1,126.01	-2,744.39	696.00
2392	-1,122.41	-2,740.75	696.00

\\Project\Projects\A-EDFC0143\CAD\Phase 8\Construction\Sheets\EDFC0143-BD-EZ.dwg (last saved: 10/20/25 4:14 PM) by [Young, John] 11/20/25 12:11 PM

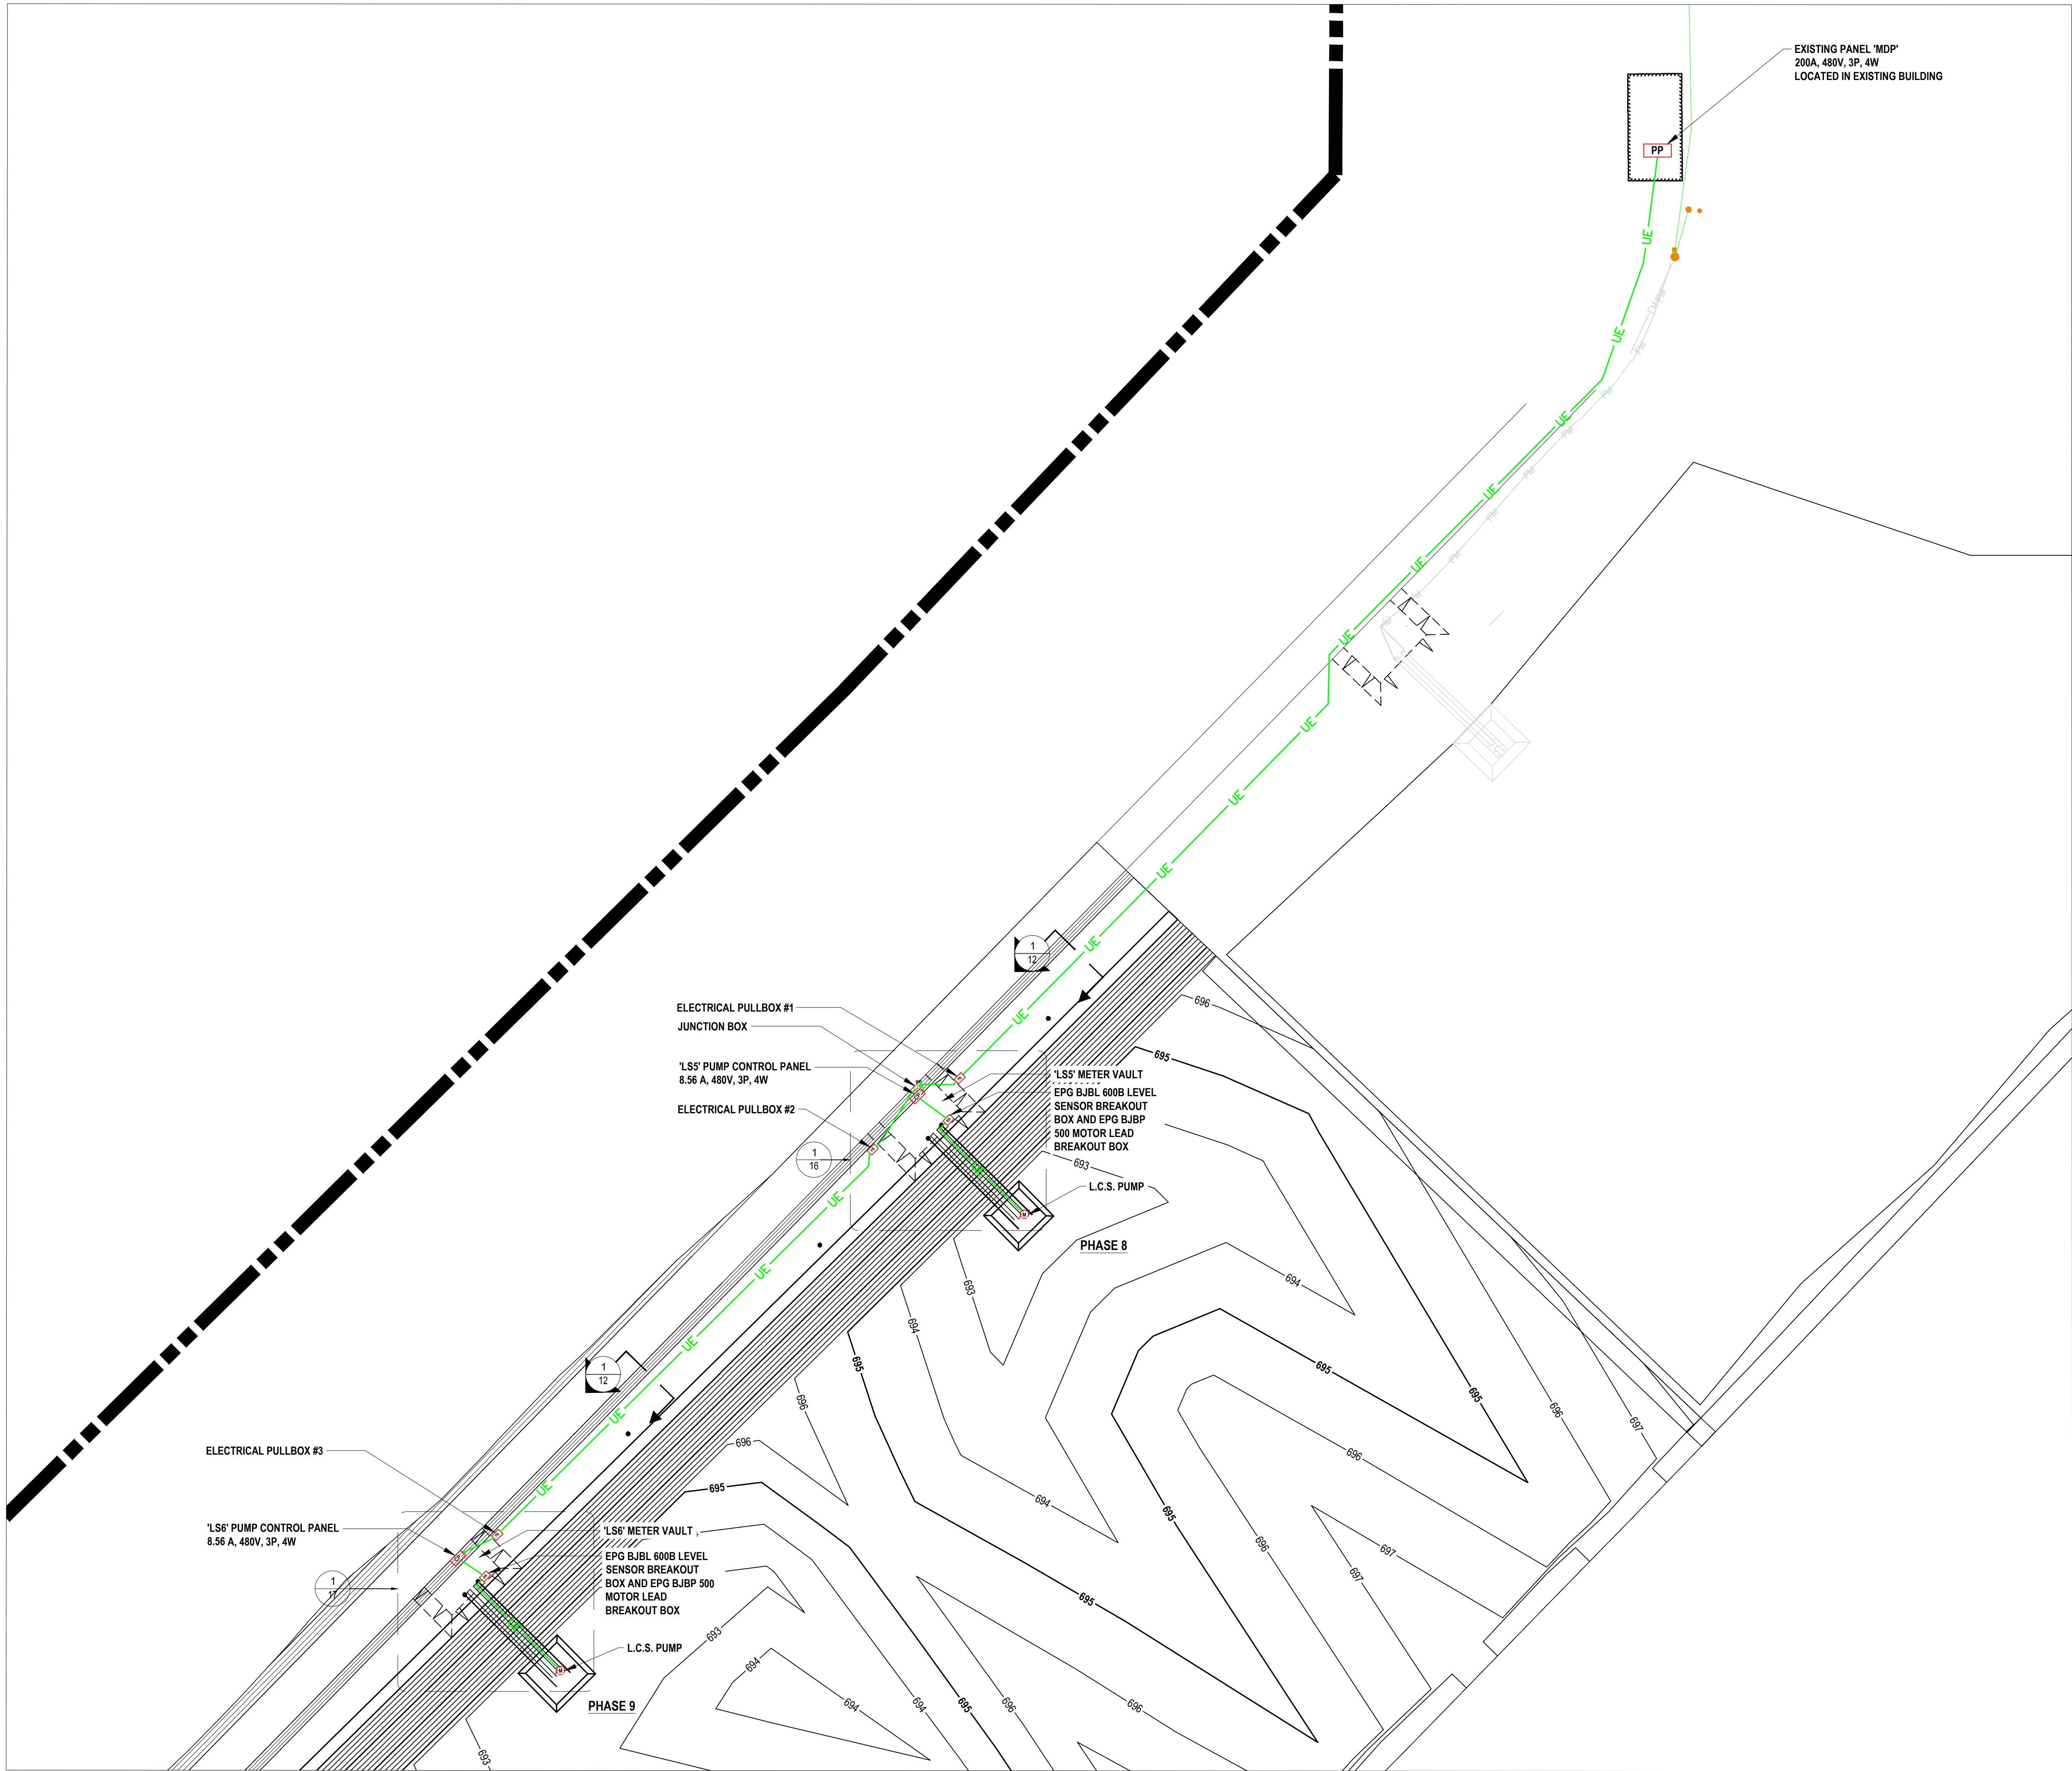

OVERALL POWER PLAN
SCALE: 1" = 60'

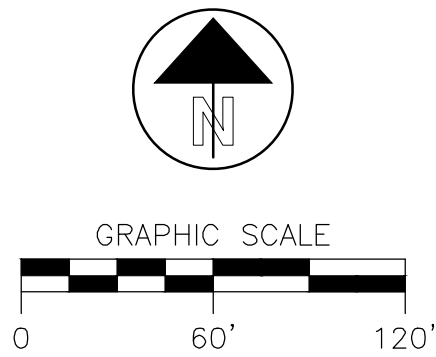

LEGEND

- JUNCTION BOX
- ELECTRICAL PULL BOX
- ELECTRICAL BREAKOUT BOX
- SIGNIFIES WEATHER PROOF ENCLOSURE
- UNDERGROUND ELECTRIC
- PUMP CONTROL PANEL
- POWER PANEL
- MOTOR

ELECTRICAL NOTES

- ELECTRICAL CONTRACTOR TO REFER TO ONE-LINE DIAGRAM FOR CIRCUIT INFORMATION.
- ELECTRICAL CONTRACTOR TO VERIFY THE LOCATION OF ALL EXISTING UTILITIES BEFORE THE START OF CONSTRUCTION.
- OWNER SUPPLIED CONDUIT TO BE INSTALLED BY ELECTRICAL CONTRACTOR.
- PVC CONDUITS SHALL BE SCH. 80 RIGID "PVC". ELBOWS AND ANY CONDUIT LOCATED ABOVE FINISHED GRADE SHALL BE "RGS" UNLESS OTHERWISE NOTED IN THE DRAWINGS.
- BURY DEPTH FOR ALL UNDERGROUND CONDUITS TO BE A MINIMUM OF 24" BELOW FINISHED GRADE. PROVIDE A WARNING MARKER TAPE AT 12" BELOW FINISHED GRADE.
- ELECTRICAL CONTRACTOR TO REFER TO LIFT PUMP DETAIL SHEETS 10-13 FOR ELECTRICAL INSTALLATION DETAILS.
- LS5 AND LS6 CONTROL PANEL RACKS TO BE CONSTRUCTED WITH TWO (2) 4" CONCRETE-FILLED SCHEDULE 40 GALVANIZED UPRIGHTS AND FIVE (5) GALVANIZED HORIZONTAL STRUTS. SET THE UPRIGHTS IN 12-INCH DIAMETER BY THREE FEET DEEP CONCRETE-FILLED HOLES.
- PULLBOXES TO BE SYNERTECH MODEL 2436TBOX36, 2'X3'X3' DEEP, WITH LID MODEL 2436T011 OR EQUAL. PULLBOXES TO BE SET 1/2' BELOW GRADE TO ALLOW FOR FUTURE VEGETATIVE COVER.
- JUNCTION BOX TO BE NEMA 4, 4X4 ENCLOSURE.
- PUMP CONTROL PANELS 'LS5' AND 'LS6' TO BE SUPPLIED BY OWNER AND INSTALLED BY ELECTRICAL CONTRACTOR.

DESCRIPTION

NO. DATE BY

1800 INDIAN WOOD CIRCLE
MAINEE, OH 43037

TEL: 419.891.2222
FAX: 419.891.1595

PROJECT DATE: NOVEMBER 2025
PROJECT NO.: DFC0143

DRAWN BY: SRG
CHECKED BY: KCD



PREPARED FOR

DEFIANCE COUNTY

BOARD OF

COMMISSIONERS

500 COURT STREET
DEFIANCE, OHIO 43512

SITE IMPROVEMENT PLAN FOR

DEFIANCE COUNTY

LANDFILL

13207 CANAL ROAD
DEFIANCE, OHIO 43512

ELECTRICAL

OVERALL POWER PLAN

14

14